



BINNERI PRESBYTERIAN CHURCH
RICHARDSON, TX
 1301 ABRAMS RD.
 RICHARDSON, TEXAS 75081

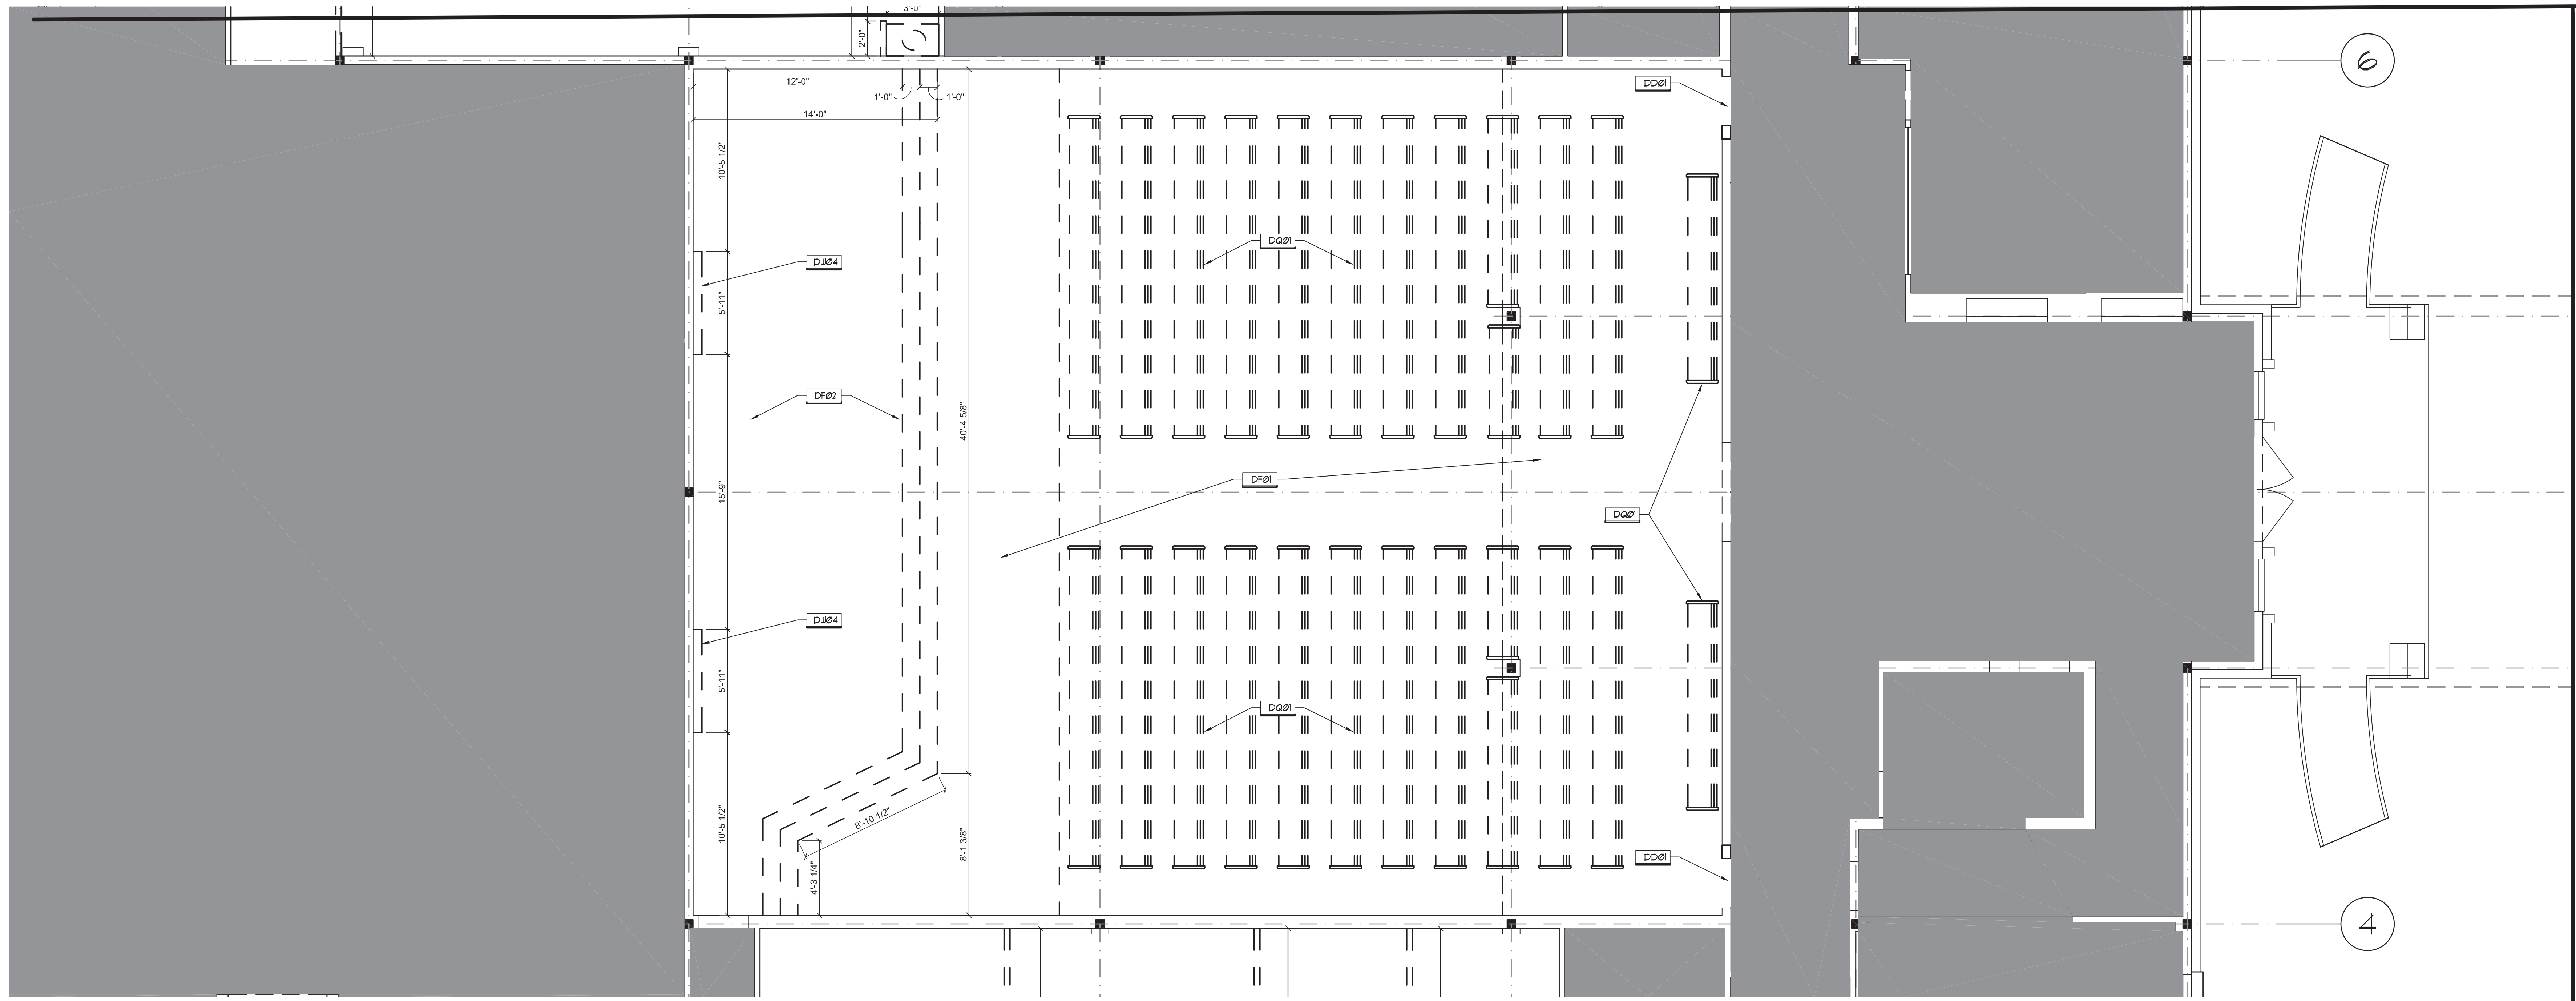

01 ENGLISH MINISTRY DEMOLITION PLAN - LEVEL 1
 1/4" = 1'-0"

DEMOLITION KEYNOTES:	
FLOORING	
DF01	EXISTING FLOORING TO BE REMOVED, PREP SLAB TO RECEIVE NEW FLOOR FINISHES
DF02	EXISTING PLATFORM TO BE REMOVED, SLAB BENEATH TO BE PREPARED FOR NEW FINISHES OR STRUCTURE
WALLS	
DW01	EXISTING WALL AREA TO BE PREPARED FOR NEW WALL FINISH
DW02	EXISTING WALL AREA TO BE REMOVED, PATCH AND REPAIR ADJACENT SURFACE
DW03	EXISTING WALL TO BE REMOVED FROM FINISH FLOOR TO 8'-0" A.F.F.
DW04	EXISTING PLASTER TO BE REMOVED, PREPARE SUBSTRATE FOR NEW FINISH. VERIFY NO STRUCTURE PRESENT, NOTIFY ARCHITECT IF FOUND.
DOORS	
DD01	EXISTING DOOR TO BE REMOVED
DD02	EXISTING DOOR TO REMAIN
GLAZING	
DG01	EXISTING GLAZING TO BE REMOVED

DEMOLITION KEYNOTES:	
ELECTRICAL	
DE01	EXISTING ELECTRICAL TO REMAIN
DE02	EXISTING ELECTRICAL TO BE REMOVED, CAP CIRCUIT FOR REUSE
DE03	EXISTING ELECTRICAL TO BE REMOVED, REMOVE WIRING BACK TO CLOSEST BRANCH CIRCUIT
FURNITURE	
DQ01	EXISTING FURNITURE / EQUIPMENT TO BE REMOVED, STORE FOR POSSIBLE REUSE
DQ02	EXISTING MILLWORK / FURNITURE TO BE REMOVED
DQ03	EXISTING RESTROOM PARTITION AND DOOR TO BE REMOVED
PLUMBING	
DP01	EXISTING PLUMBING FIXTURE TO REMAIN, VERIFY ALL MECHANICAL PARTS TO BE IN PROPER WORKING ORDER
DP02	EXISTING PLUMBING FIXTURE TO BE REMOVED, CAP WATER AND SEWER FOR FUTURE REUSE
DP03	EXISTING PLUMBING FIXTURE TO BE REMOVED, CAP WATER AND SEWER

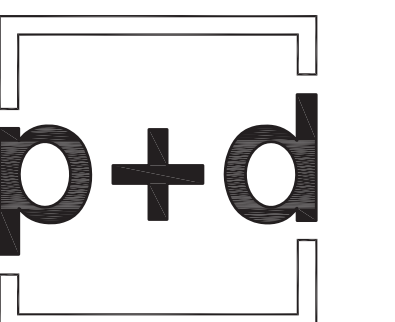

poole+drennan
design studio

931 N Edgerfield Ave
 Dallas, Texas 75208
 PH: 855.707.0104
 info@poole+drennan.com

COPYRIGHT
 THESE DRAWINGS ARE THE PROPERTY OF
 POOLE+DRENNAN DESIGN STUDIO AND
 SHALL NOT BE DUPLICATED, DISCLOSED OR
 REUSED WITHOUT THE WRITTEN CONSENT
 OF POOLE+DRENNAN DESIGN STUDIO

DRAWN BY:	KJC
CHECKED BY:	DAD
DATE:	04.12.2017
REVISIONS:	
CITY COMMENTS	06.12.2017

PROJECT NO.: **16054**
 SHEET TITLE:

**PHASE I-ENGLISH
 MINISTRY DEMO
 FLOOR PLAN**

SHEET NO.: **D-102**