




BINNERRI PRESBYTERIAN CHURCH
RICHARDSON, TX
 1301 ABRAMS RD.
 RICHARDSON, TEXAS 75081

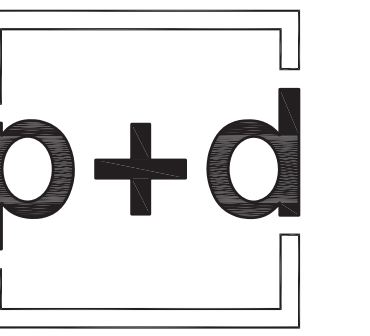

poole+drennan
 design studio

931 N Edgewood Ave
 Dallas, Texas 75209
 Ph: 972.707.0104
 info@poole+drennan.com


COPYRIGHT
 THESE DRAWINGS ARE THE PROPERTY OF
 POOLE+DRENNAN DESIGN STUDIO AND
 SHALL NOT BE DUPLICATED, DISCLOSED OR
 REUSED WITHOUT THE WRITTEN CONSENT
 OF POOLE+DRENNAN DESIGN STUDIO

DRAWN BY: **KJC**
 CHECKED BY: **DAD**
 DATE: **04.12.2017**
 REVISIONS:

PROJECT NO.: **16054**
 SHEET TITLE:

**PHASE I-KINDER
 SANCTUARY
 DEMO RCP**

SHEET NO.: **D-113**

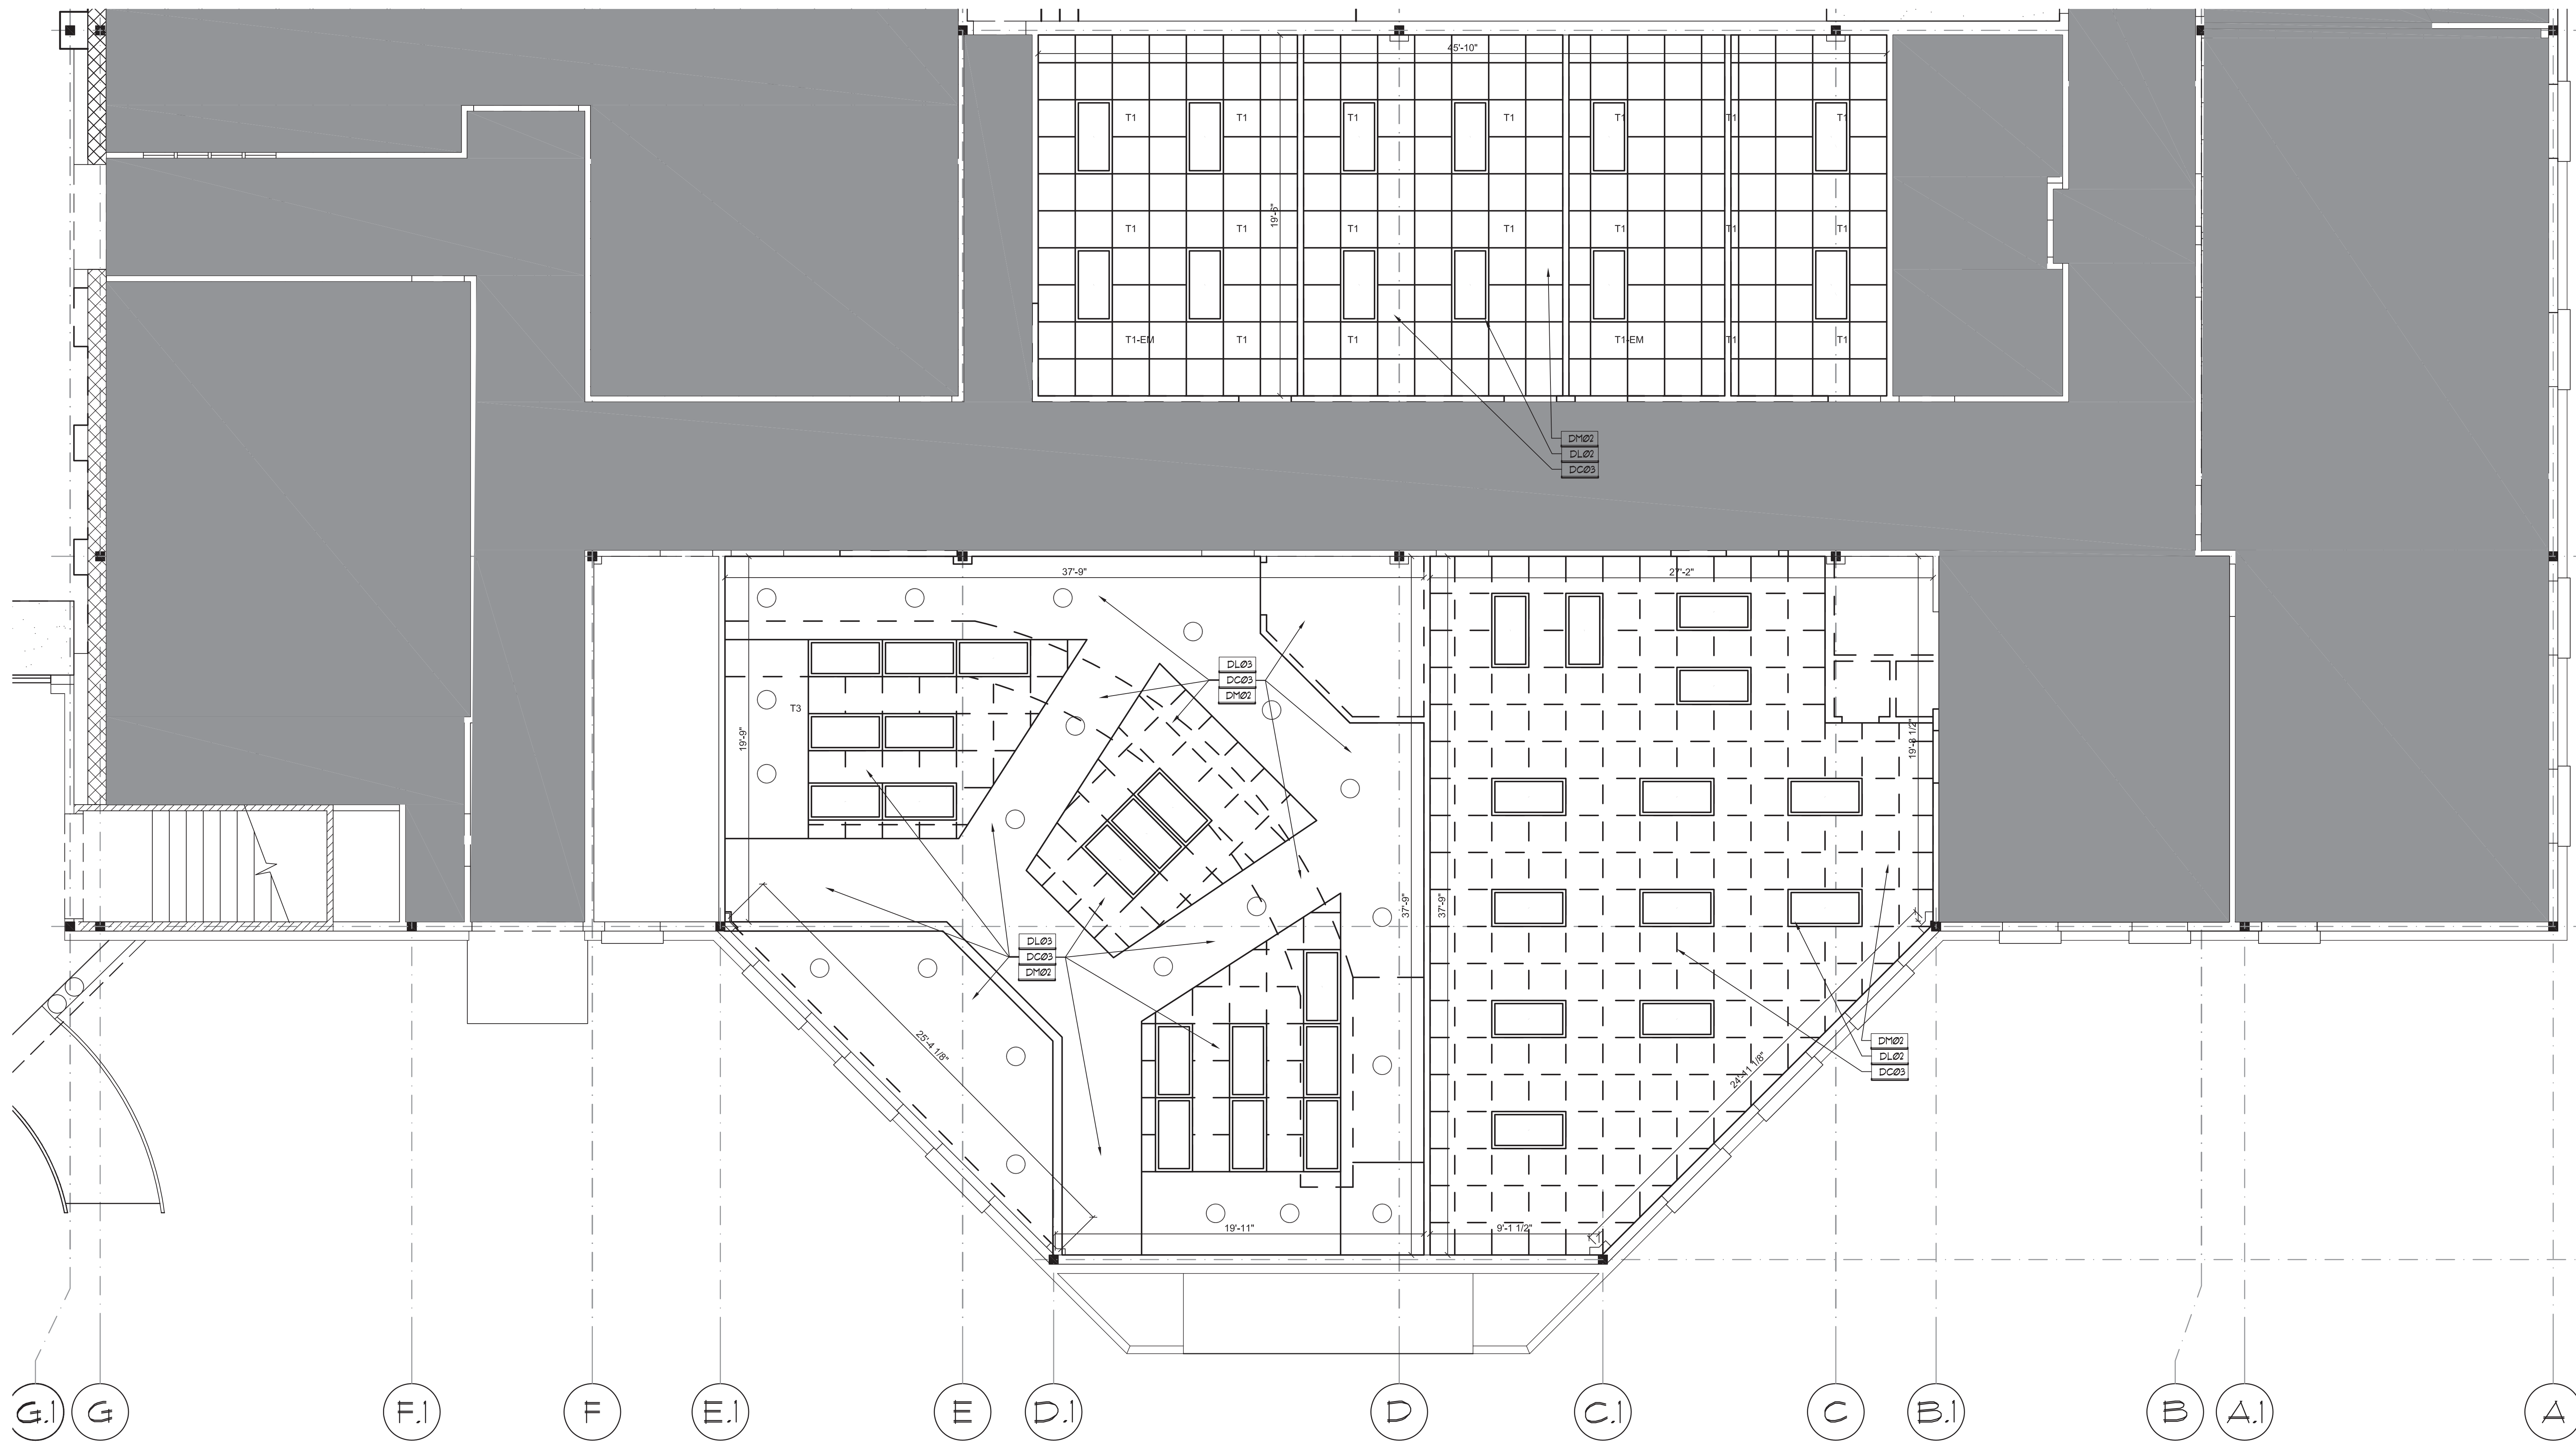

01 KINDER SANCTUARY | PLAYROOM DEMOLITION REFLECTED CEILING PLAN - LEVEL 1
 1/4" = 1'-0"

DEMOLITION KEYNOTES:	
MECHANICAL	
DM01	EXISTING HVAC SYSTEM TO REMAIN
DM02	EXISTING HVAC SYSTEM TO BE REMOVED / REALLOCATED
LIGHTING	
DL01	EXISTING LIGHTING TO REMAIN, CLEAN AND RELAMP FOR PROPER WORKING ORDER
DL02	EXISTING LIGHTING TO BE REMOVED, CAP CIRCUIT FOR REUSE
DL03	EXISTING LIGHTING TO BE REMOVED, REMOVE WIRING BACK TO CLOSEST BRANCH CIRCUIT
CEILING	
DC01	EXISTING CEILING AREA TO BE PREPARED TO RECEIVE NEW CEILING FINISHES
DC02	EXISTING CEILING TO REMAIN (ADJUST CEILING GRID AS REQ'D)
DC03	EXISTING CEILING TO BE REMOVED
DC04	EXISTING CEILING GRID TO REMAIN, REPLACE TILES WITH NEW

FILE: C:\Users\Kory_Cooper\AppData\Local\Temp\WpPublish_12048\0-100.dwg
 SCALE: AS DATE/TIME: Apr 13, 2017 10:23am
 USER: Kory_Cooper XREF(s): xbase-LEVEL1 Phase 1.dwg xbase-GRID1.dwg titleblock_3042.dwg xbase-LEVEL2.dwg xbase-GRID2.dwg Demo Keynotes.dwg