


Plotted By: Dan Habetter 24 May, 2017 Drawing File: E:\Dropbox (EnviroDesign)\EnviroDesign Team Folder\Current\2017-055 Cinergy Amarillo\2017-055E103.dwg

ALL DRAWINGS AND WRITTEN MATERIAL APPEARING HEREIN CONSTITUTE ORIGINAL AND UNPUBLISHED WORK OF THE ENGINEER AND MAY NOT BE DUPLICATED, USED OR DISCLOSED WITHOUT WRITTEN CONSENT OF ENVIRODESIGN, INC. © 2017 ENVIRODESIGN, INC. ALL RIGHTS RESERVED.

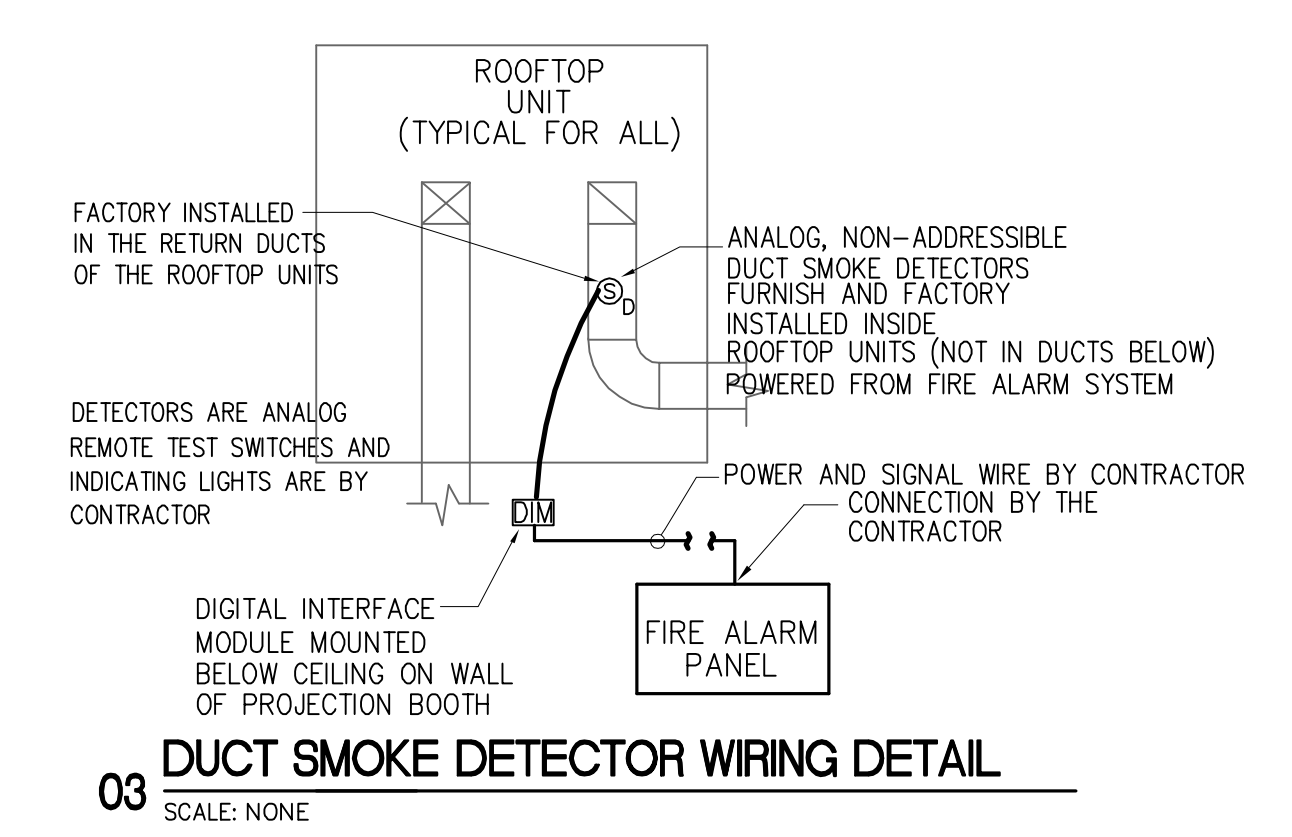

Studio Collaborative, LLC.
 800 Jackson | Suite 600 | Dallas, TX 75202
 260 Peachtree Street | Suite 500 | Atlanta, GA 30303

ARCHITECT
 5G Studio Collaborative, LLC.
 800 Jackson St., Suite 600
 Dallas, TX 75202
 Rick Walker - 214.670.0050

STRUCTURAL ENGINEER
 L.A. Fuess Partners Engineers
 3333 Lee Parkway, Suite 300
 Dallas, TX 75219
 Jeff Tracy - 214.811.0110

MEP ENGINEER
 EnviroDesign, Inc.
 900 Ranch Rd 620 So., Suite C101-301
 Austin, TX 78738
 Sam Patton - 512.693.9015
 Texas PE Firm Number 1-3847

24 May 2017

 Sam L. Patton, P.E.
 TX PE# 57170

DRAWINGS & SPECIFICATIONS ARE THE PROPERTY OF ENVIRODESIGN. COPIES OF THE DRAWINGS & SPECIFICATIONS RETAINED BY THE CLIENT MAY BE UTILIZED ONLY FOR HIS USE & FOR OCCUPANCY OF THE PROJECT FOR WHICH THEY WERE PREPARED, & NOT FOR THE CONSTRUCTION OF ANY OTHER PROJECT.
 P O Y E C

REV.	DATE	PERMIT ISSUE	ISSUE
5/12/17	5/12/17	PERMIT ISSUE	
5/24/17	5/24/17	ISSUE FOR BID	

CINERGY AMARILLO

SHEET DESCRIPTION
ROOF PLAN
FIRE ALARM

2016-151
 PROJECT NUMBER

E10.3
 SHEET NUMBER

01 ROOF PLAN - FIRE ALARM
 SCALE: 3/32"=1'-0"