



BAR ELECTRICAL SCHEDULE													
ITEM NO.	DESCRIPTION	TERMINATE	VOLTS	CYCLE	PHASE	AMPS	KW	HP	LOCATION	AFF	CONNECTION	NEMA	REMARKS
B1	WALK-IN BEER COOLER LIGHTS AND DOOR HEATER.	JB	120	60	1PH	10			DFA	VERIFY	DIRECT		B.T.C. DOWN FROM CEILING TO TOP OF WALK-IN COOLER. CONNECT LIGHTS & DOOR HEATER. ELECTRICAL CONTRACTOR TO MOUNT EXTRA LIGHT FIXTURES IN WALK-IN COOLER.
B1.2	WALK-IN BEER COOLER EVAP. COIL	JB	120	60	1PH	4.2			DFA	VERIFY	DIRECT		B.T.C. DOWN FROM CEILING THRU TOP OF WALK-IN FOR BEER COOLER EVAPORATOR COIL.
B1.3	WALK-IN BEER COOLER COMPRESSOR	JB	208/230	60	3PH	8.8		1.5HP	ROOF	VERIFY	DIRECT		B.T.C. MEDIUM TEMP. PRE-ASSEMBLED REMOTE AIR COOLED HERMETIC OUTDOOR OP., REFRIGERANT R404A.
B5	CARBONATOR, BAG IN BOX SYRUP TANK RACK	DCO	120	60	1	15			WALL	74"	CORD & PLUG	5-15P	FOR CARBONATOR PUMP. - SIX LOCATIONS
B6	ICE CUBER MACHINE	JB	208	60	3	12.2			WALL	74"	DIRECT		20AMP MAX CIRCUIT. - TWO LOCATIONS
B6.1	REMOTE ICE CONDENSER - 2 LOCATIONS.		120										POWER FOR ICE REMOTE WILL COME FROM ICE MAKER.
B9	BUBBLER, SINGLE - 3 LOCATION	DCO	120	60	1	3			WALL	38"	CORD & PLUG	5-15P	
B10	GLASSWASHER	JB	120	60	1	16			WALL	12"	DIRECT		B.T.C.
B21	LIQUOR BOTTLE DISPLAY - 2 LOCATIONS	JB	120	60	1	5			FLOOR	6"	DIRECT		B.T.C ON DCO IN COUNTER, 6" CORD & PLUG, TWO LOCATIONS.
B22	P.O.S. UNITS, BY OWNER - 2 LOCATIONS	DCO	120	60	1	15			FLOOR	48"	CORD & PLUG	5-15P	15 AMP., DEDICATED ISOLATED CIRCUIT, FOR OWNER FURNISHED EQUIPMENT.
B24	POS PRINTER - 2 LOCATIONS.	DCO	120	60	1	15			FLOOR	48"	CORD & PLUG	5-15P	FOR PRINTER MACHINE.
	DATA - POS PRINTER/POS SYSTEM - 2 LOCATIONS	JB							FLOOR	48"			EMPTY CONDUIT FOR DATA CONTROL LINES FOR POS/PRINTER SYSTEM.
B25	BACK BAR COOLER, PASS THRU - 2 REQ.	DCO	120	60	1	15			FLOOR	6"	CORD & PLUG	5-15P	B.T.C., AT TWO LOCATIONS
B26	FROZEN DRINK MACHINE - 4 REQ.	JB	208-230	60	1	17		(2) 1/4	WALL	36"			B.T.C. - TWO LOCATIONS.
BCOV	CONVENIENT OUTLET	DCO	120	60	1	15			WALL	50"	CORD & PLUG	5-15P	3 LOCATIONS
BPR	PRINTER	DCO	120	60	1	15			WALL	50"	CORD & PLUG	5-15P	FOR PRINTER MACHINE. DEDICATED ISOLATED
	DATA, FOR PRINTER	JB							WALL	50"			EMPTY CONDUIT FOR DATA CONTROL LINES FOR POS/PRINTER SYSTEM.

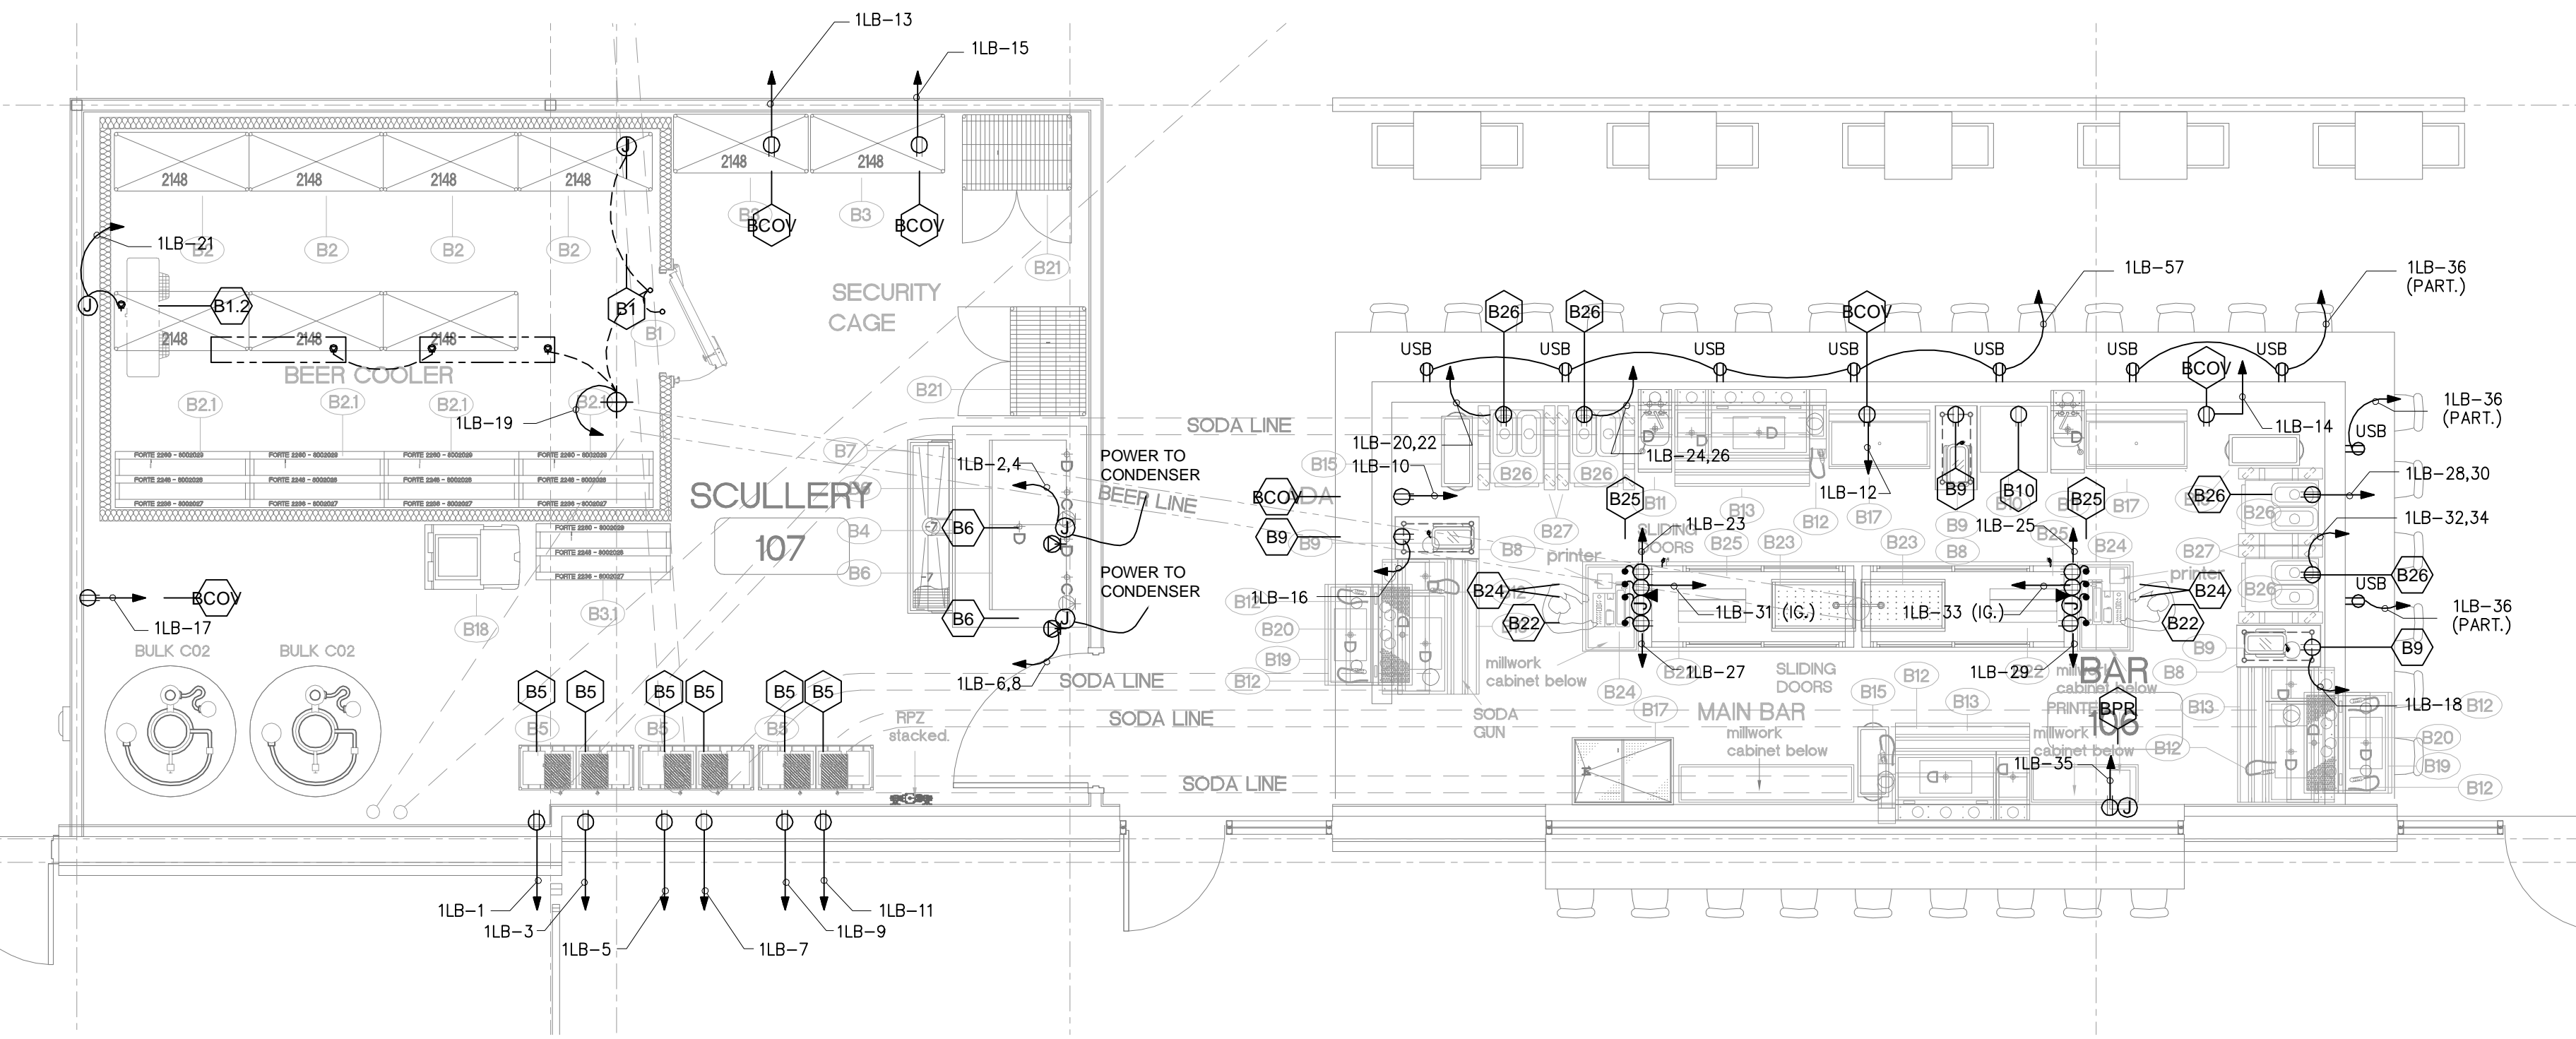

01 ENLARGED BAR PLAN - POWER  
SCALE: 1/4"=1'-0"

BOWLING BAR ELECTRICAL SCHEDULE													
ITEM NO.	DESCRIPTION	TERMINATE	VOLTS	CYCLE	PHASE	AMPS	KW	HP	LOCATION	AFF	CONNECTION	NEMA	REMARKS
BBCOV	CONVENIENT OUTLET - 3 LOCATIONS	DCO	120	60	1	15			WALL	50"	CORD & PLUG	5-15P	
BB1	SODA BEVERAGE POST / DRINK DISPENSER	DCO	120	60	1	6			WALL	18"	CORD & PLUG	5-15P	
BB1.1	ICE CUBER MACHINE	JB	208	60	1	11			WALL	74"	DIRECT		20AMP MAX CIRCUIT- 3 WIRE W/DEDICATED NEUTRAL FOR 120
BB3	ICE CUBER MACHINE	JB	208	60	1	13.4			WALL	74"	DIRECT		20AMP MAX CIRCUIT.
BB3.1	REMOTE CONDENSER	JB											POWER SUPPLY WILL COME FOR ICE MAKER.
BB6	CARBONATOR, BAG IN BOX SYRUP TANK RACK	DCO	120	60	1	15			WALL	78"	CORD & PLUG	5-15P	FOR CARBONATOR. - (4) LOCATIONS
BB9	GLASSWASHER	JB	120	60	1	16			WALL	12"	DIRECT		B.T.C.
BB12	BUBBLER, SINGLE - 3 LOCATION	DCO	120	60	1	8			WALL	38"	CORD & PLUG	5-15P	
BB16	WALK-IN BEER COOLER LIGHTS AND DOOR HEATER.	JB	120	60	1PH	10			DFA	VERIFY	DIRECT		B.T.C. DOWN FROM CEILING TO TOP OF WALK-IN COOLER. CONNECT LIGHTS & DOOR HEATER. ELECTRICAL CONTRACTOR TO MOUNT EXTRA LIGHT FIXTURES IN WALK-IN COOLER.
BB16.2	WALK-IN BEER COOLER EVAP. COIL	JB	120	60	1PH	4.2			DFA	VERIFY	DIRECT		B.T.C. DOWN FROM CEILING THRU TOP OF WALK-IN FOR BEER COOLER EVAPORATOR COIL.
BB16.3	WALK-IN BEER COOLER COMPRESSOR	JB	208/230	60	3PH	8.8		1.5HP	ROOF	VERIFY	DIRECT		B.T.C. MEDIUM TEMP. PRE-ASSEMBLED REMOTE AIR COOLED HERMETIC OUTDOOR OP., REFRIGERANT R404A.
BB21	REFRIGERATED BACKBAR CABINET - 2 LOCATIONS.	DCO	120	60	1	5.2		1/5	FLOOR	6"	DIRECT	5-15P	B.T.C ON DCO IN COUNTER, 6" CORD & PLUG, TWO LOCATIONS.
	P.O.S. UNITS, BY OWNER - 2 LOCATIONS.	DCO	120	60	1	15			WALL	48"	CORD & PLUG	5-15P	15 AMP., DEDICATED ISOLATED CIRCUIT, FOR OWNER FURNISHED EQUIPMENT.
BB24	POS PRINTER - 2 LOCATIONS.	DCO	120	60	1	15			WALL	48"	CORD & PLUG	5-15P	FOR PRINTER MACHINE.
	DATA - POS PRINTER/POS SYSTEM - 2 LOCATIONS	JB							WALL	48"			EMPTY CONDUIT FOR DATA CONTROL LINES FOR POS/PRINTER SYSTEM.
BB23	LIQUOR BOTTLE DISPLAY - 2 LOCATIONS	JB	120	60	1	5			FLOOR	6"	DIRECT		B.T.C ON DCO IN COUNTER, 6" CORD & PLUG, TWO LOCATIONS.
BB26	FROZEN DRINK MACHINE - 2 REQ.	JB	208-230	60	1	17		(2) 1/4	WALL	36"			B.T.C. - FOUR LOCATIONS.

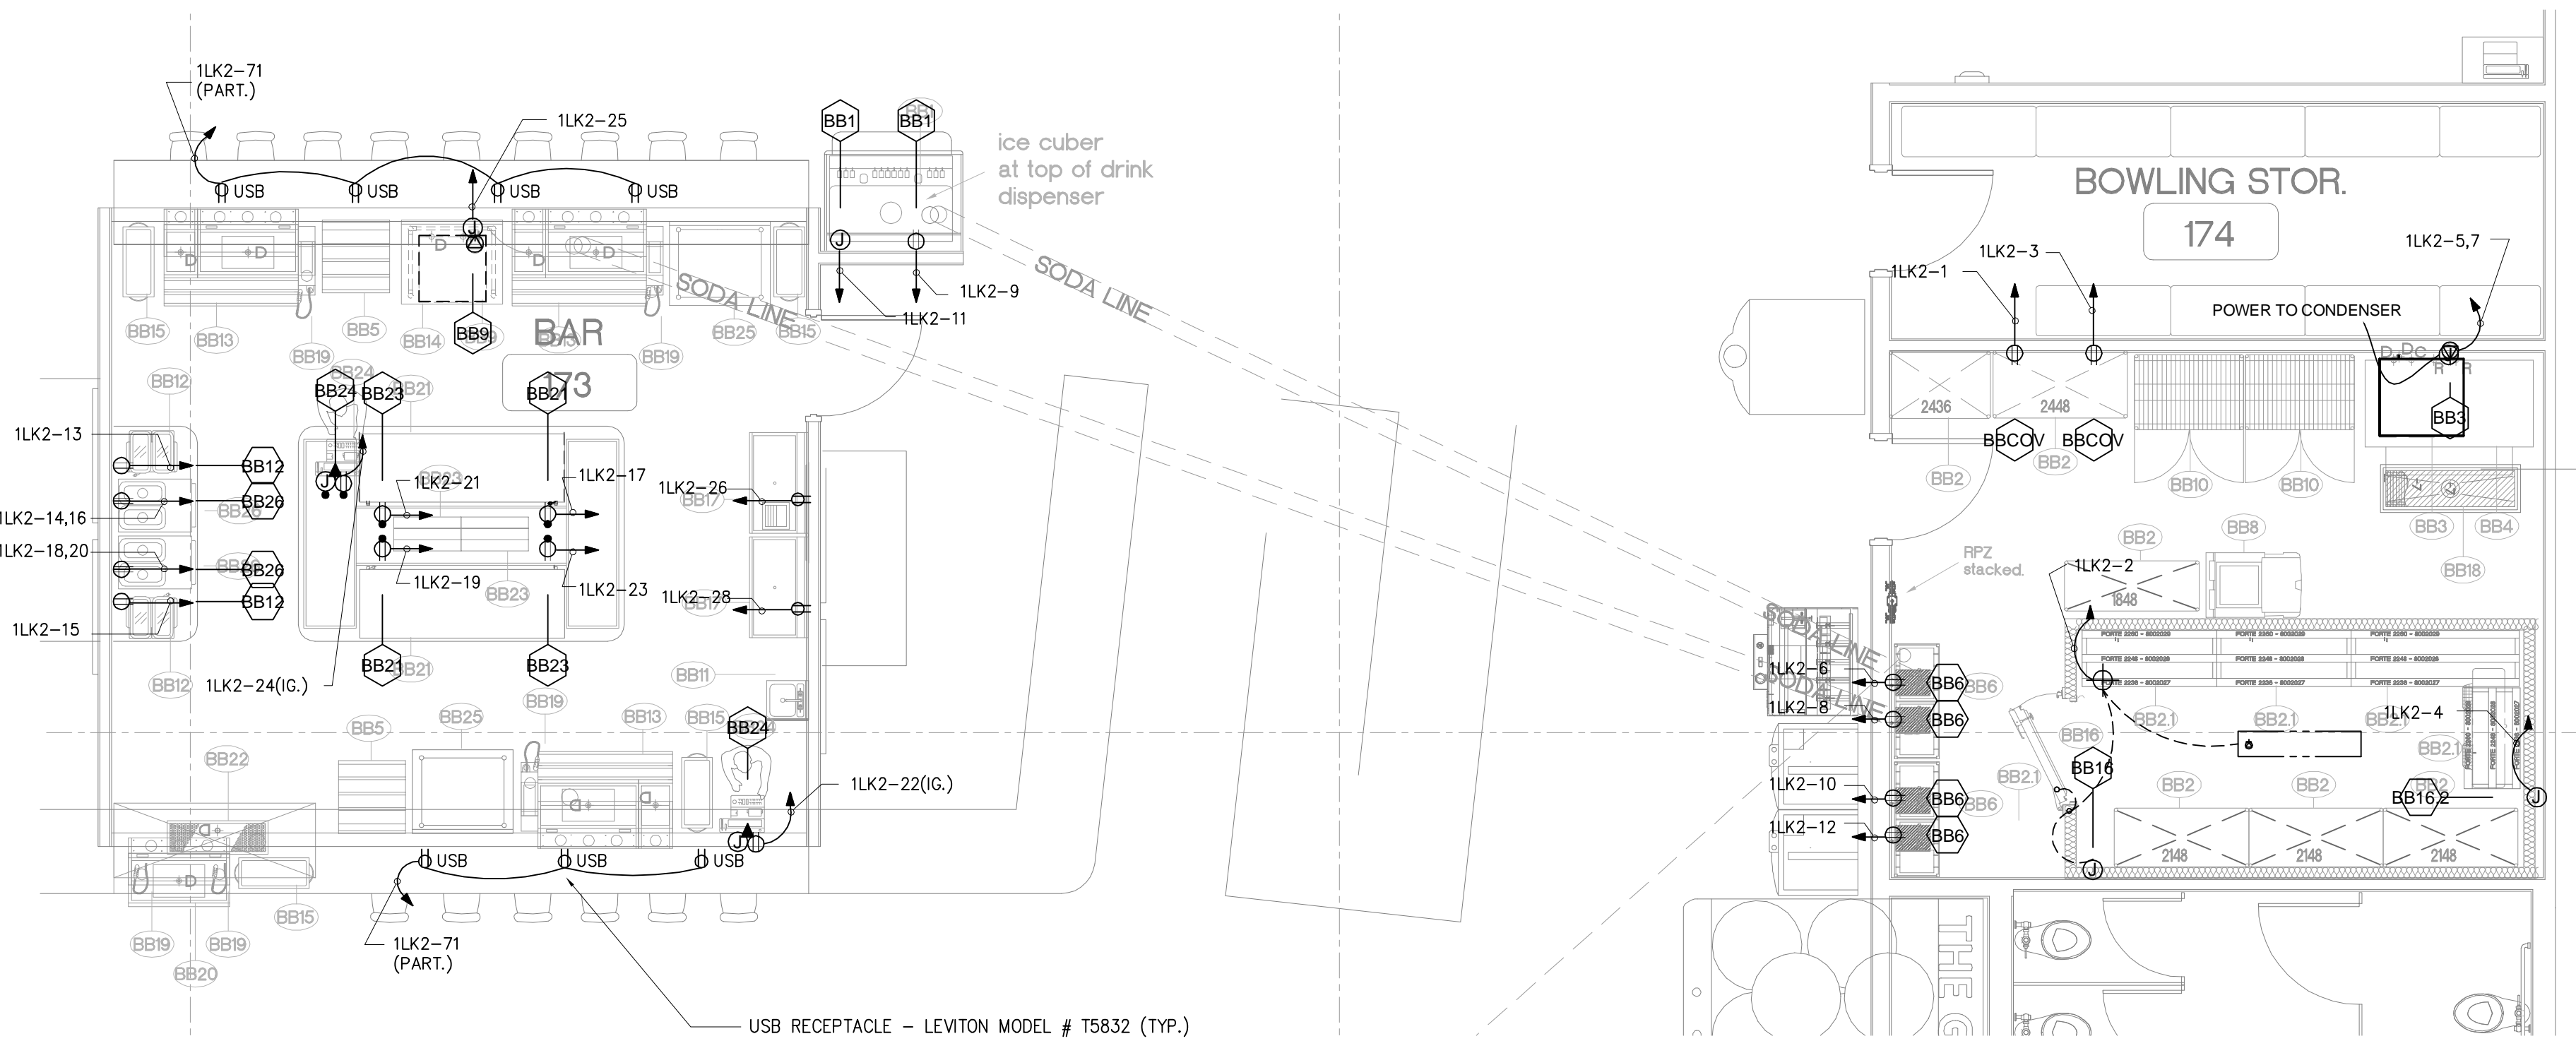

02 ENLARGED BAR PLAN - POWER  
SCALE: 1/4"=1'-0"



800 Jackson | Suite 600 | Dallas, TX 75202  
260 Peachtree Street | Suite 500 | Atlanta, GA 30303

ARCHITECT  
6G Studio Collaborative, LLC.  
800 Jackson St., Suite 600  
Dallas, TX 75202  
Rick Walker - 214.670.0050

STRUCTURAL ENGINEER  
L.A. Fuess Partners Engineers  
3333 Lee Parkway, Suite 300  
Dallas, TX 75219  
Jeff Tracy - 214.811.0110

MEP ENGINEER  
EnviroDesign, Inc.  
900 Ranch Rd #200 So., Suite C101-301  
Austin, TX 78738  
Sam Patton - 512.693.9015  
Issa P. Form Number 1-2847



DRAWINGS & SPECIFICATIONS ARE THE PROPERTY OF ENVIRODESIGN. COPIES OF THE DRAWINGS & SPECIFICATIONS RETAINED BY THE CLIENT MAY BE UTILIZED ONLY FOR HIS USE & FOR OCCUPANCY OF THE PROJECT FOR WHICH THEY WERE PREPARED, & NOT FOR THE CONSTRUCTION OF ANY OTHER PROJECT.

REV.	DATE	PERMIT ISSUE	ISSUE
5/12/17		PERMIT ISSUE	
5/24/17		ISSUE FOR BID	

CINERGY AMARILLO

SHEET DESCRIPTION  
ENLARGED PLANS - POWER

2016-151  
PROJECT NUMBER

E5.3  
SHEET NUMBER