



Plotted By: Dan Habetter 24 May, 2017 Drawing File: E:\Dropbox (EnviroDesign)\EnviroDesign Team Folder\Current\2017-055 Cinergy Amarillo\2017-055E82.dwg

ALL DRAWINGS AND WRITTEN MATERIAL APPEARING HEREIN CONSTITUTE ORIGINAL AND UNPUBLISHED WORK OF THE ENGINEER AND MAY NOT BE DUPLICATED, USED OR DISCLOSED WITHOUT WRITTEN CONSENT OF ENVIRODESIGN, INC. © 2017 ENVIRODESIGN, INC. ALL RIGHTS RESERVED.

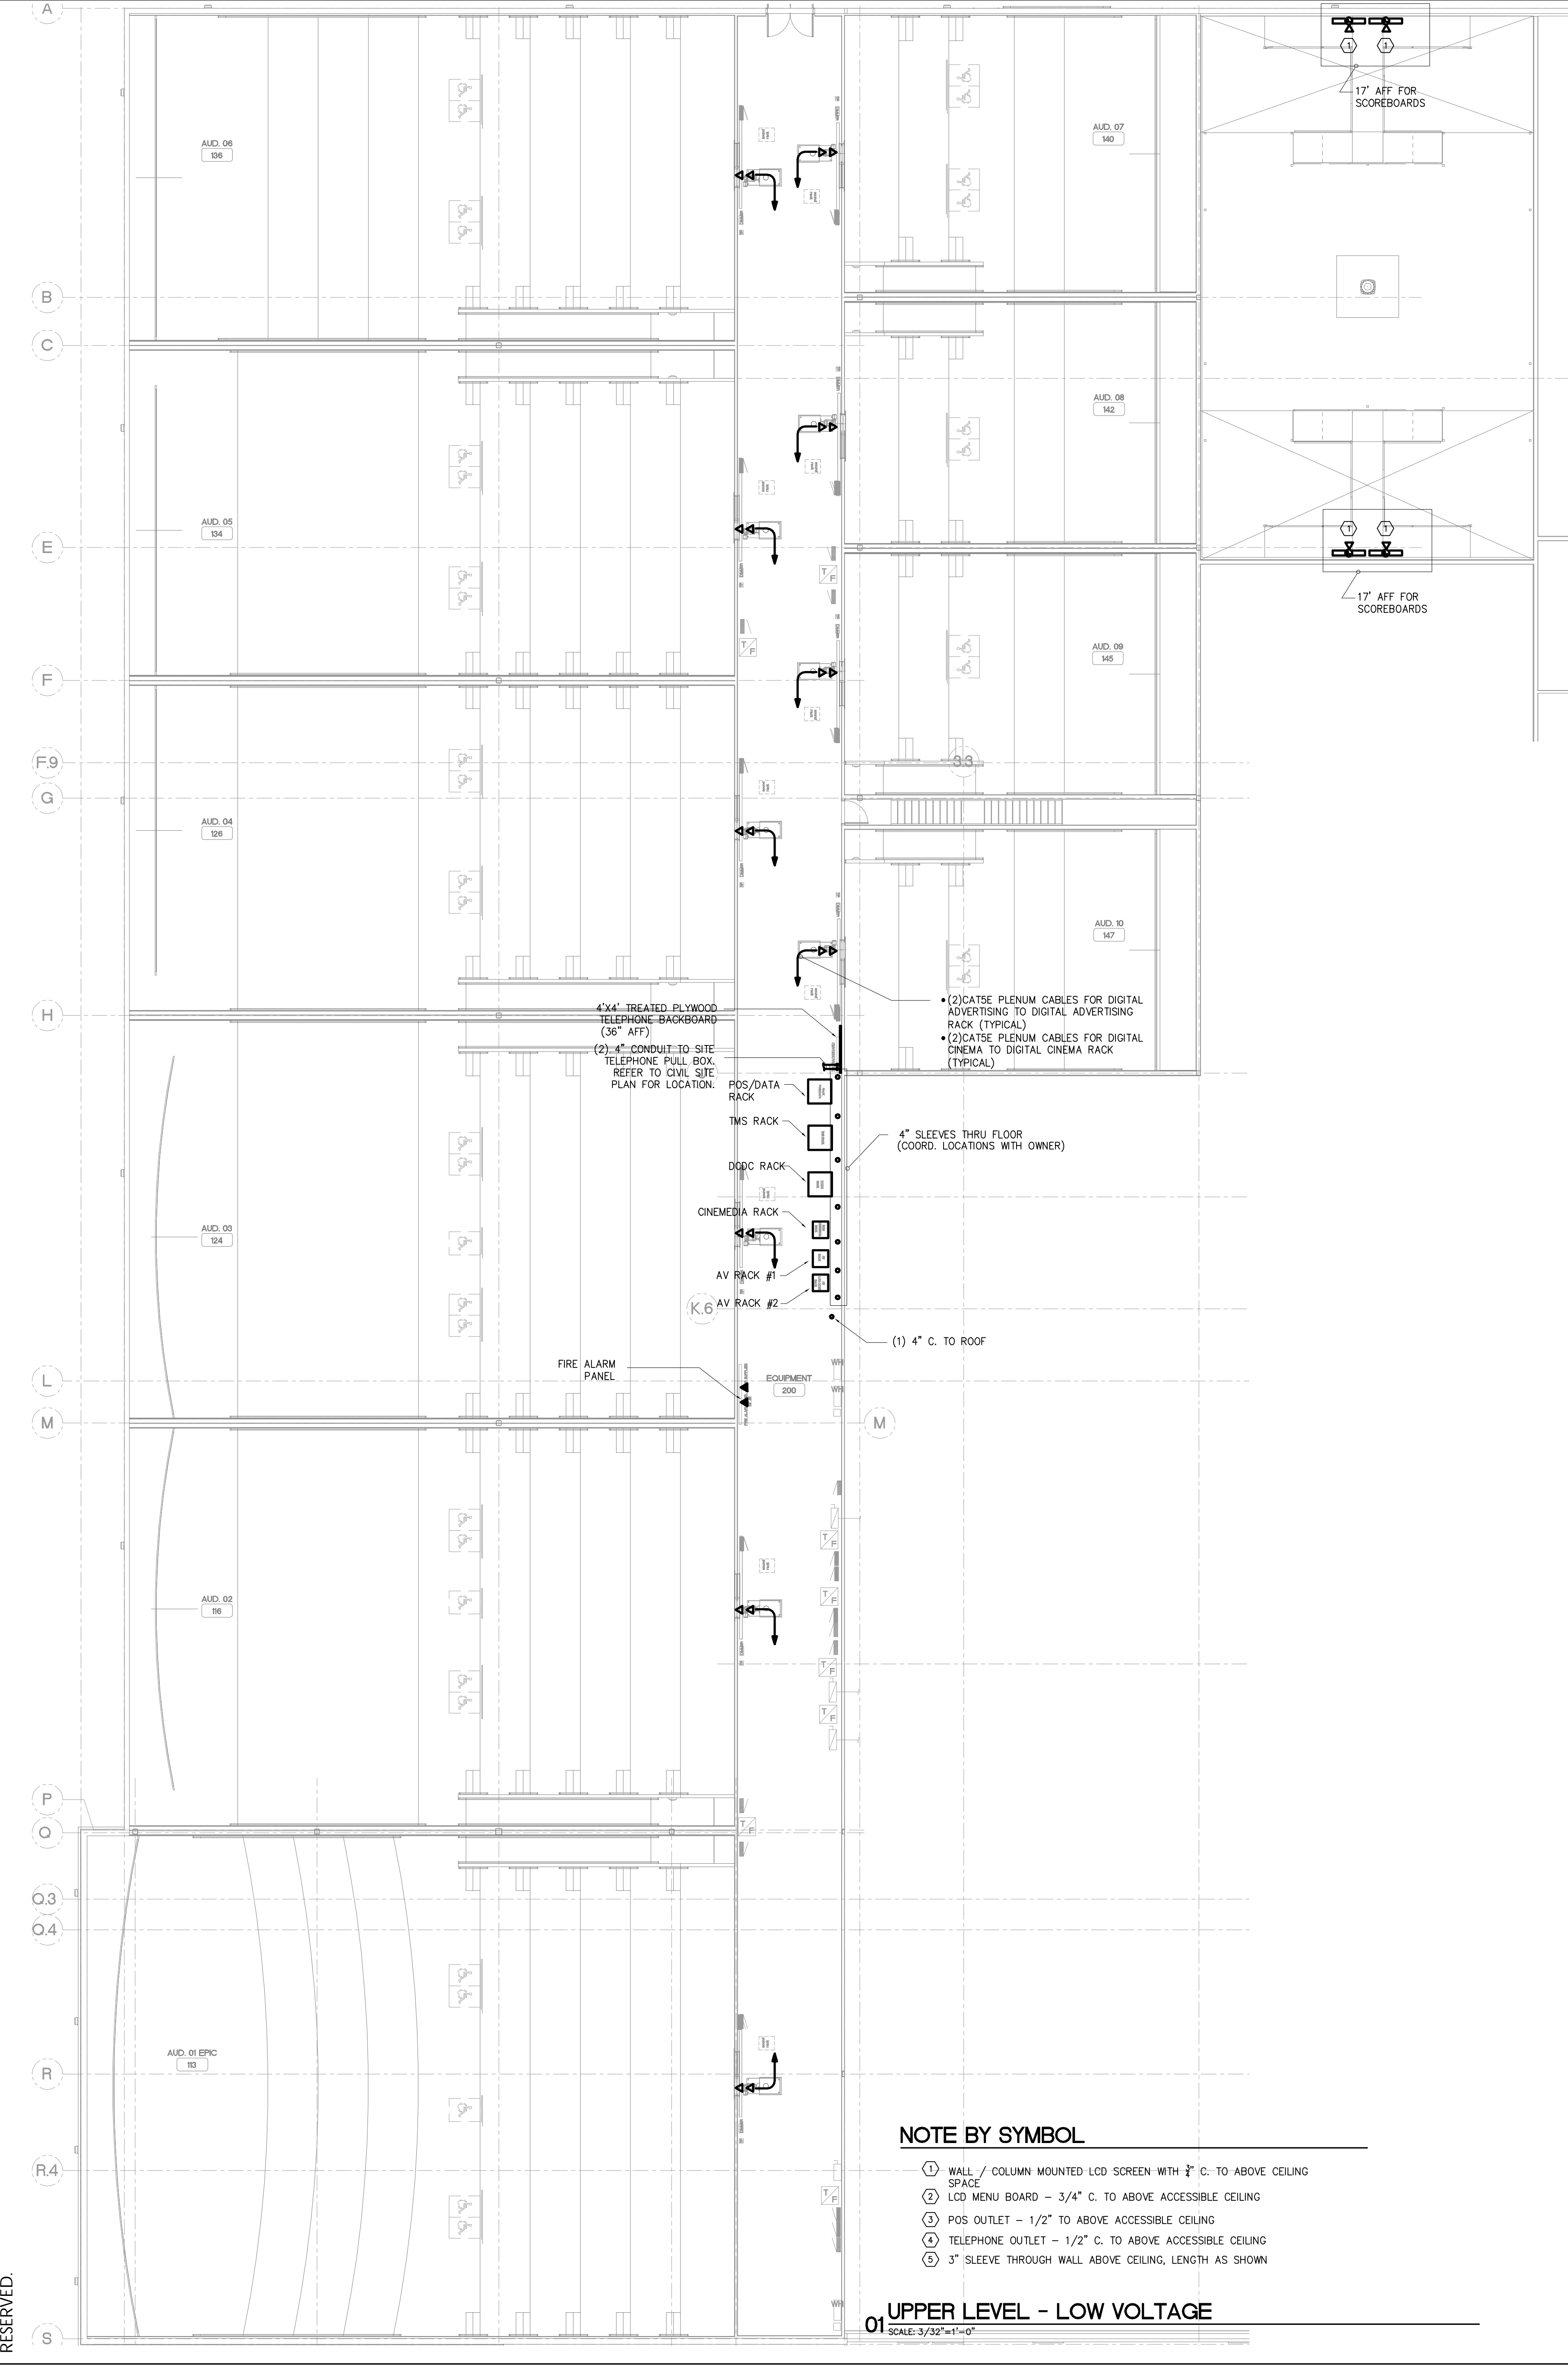


- NOTE BY SYMBOL**
- ① WALL / COLUMN MOUNTED LCD SCREEN WITH 1/2" C. TO ABOVE CEILING SPACE
 - ② LCD MENU BOARD - 3/4" C. TO ABOVE ACCESSIBLE CEILING
 - ③ POS OUTLET - 1/2" TO ABOVE ACCESSIBLE CEILING
 - ④ TELEPHONE OUTLET - 1/2" C. TO ABOVE ACCESSIBLE CEILING
 - ⑤ 3" SLEEVE THROUGH WALL ABOVE CEILING, LENGTH AS SHOWN

01 UPPER LEVEL - LOW VOLTAGE
SCALE: 3/32"=1'-0"

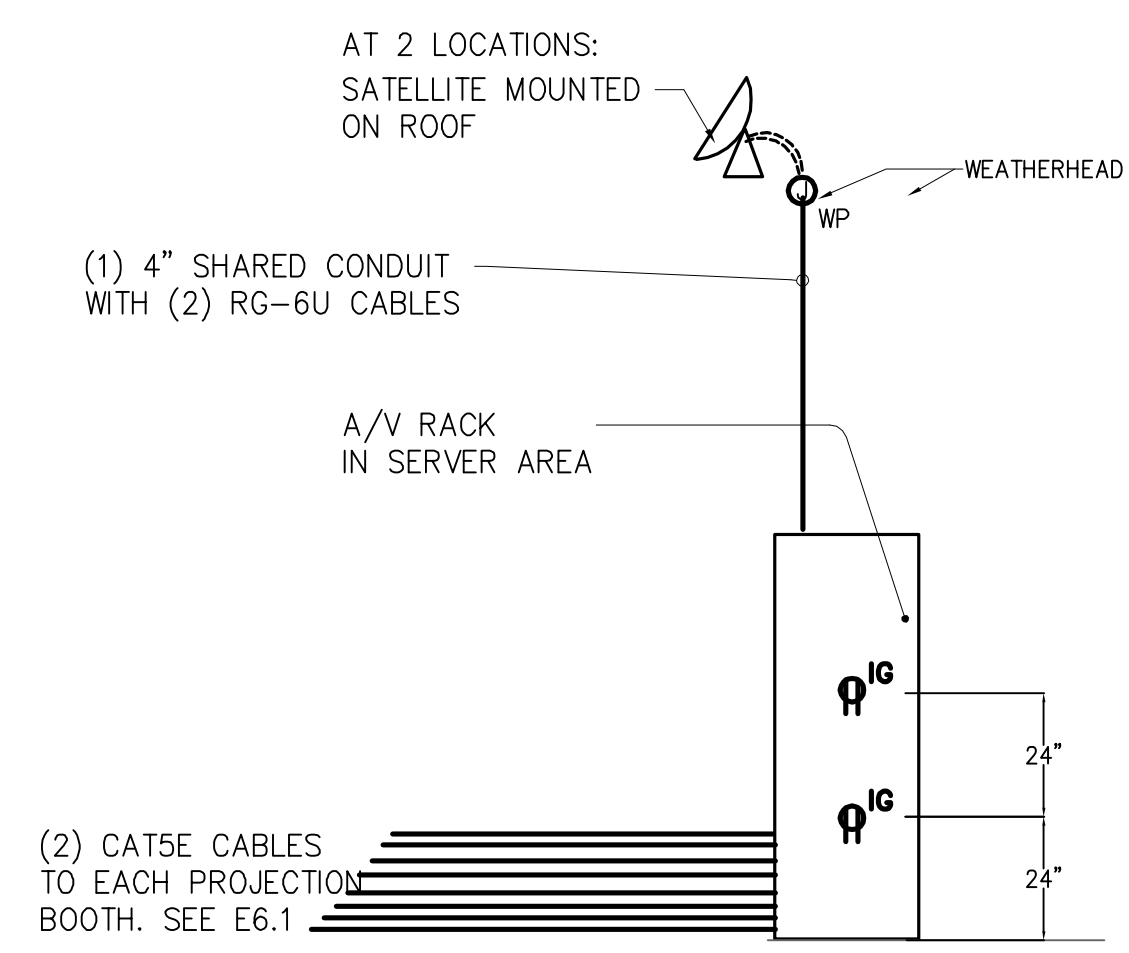

03 DIGITAL ADVERTISING A/V RISER DIAGRAM
SCALE: NONE

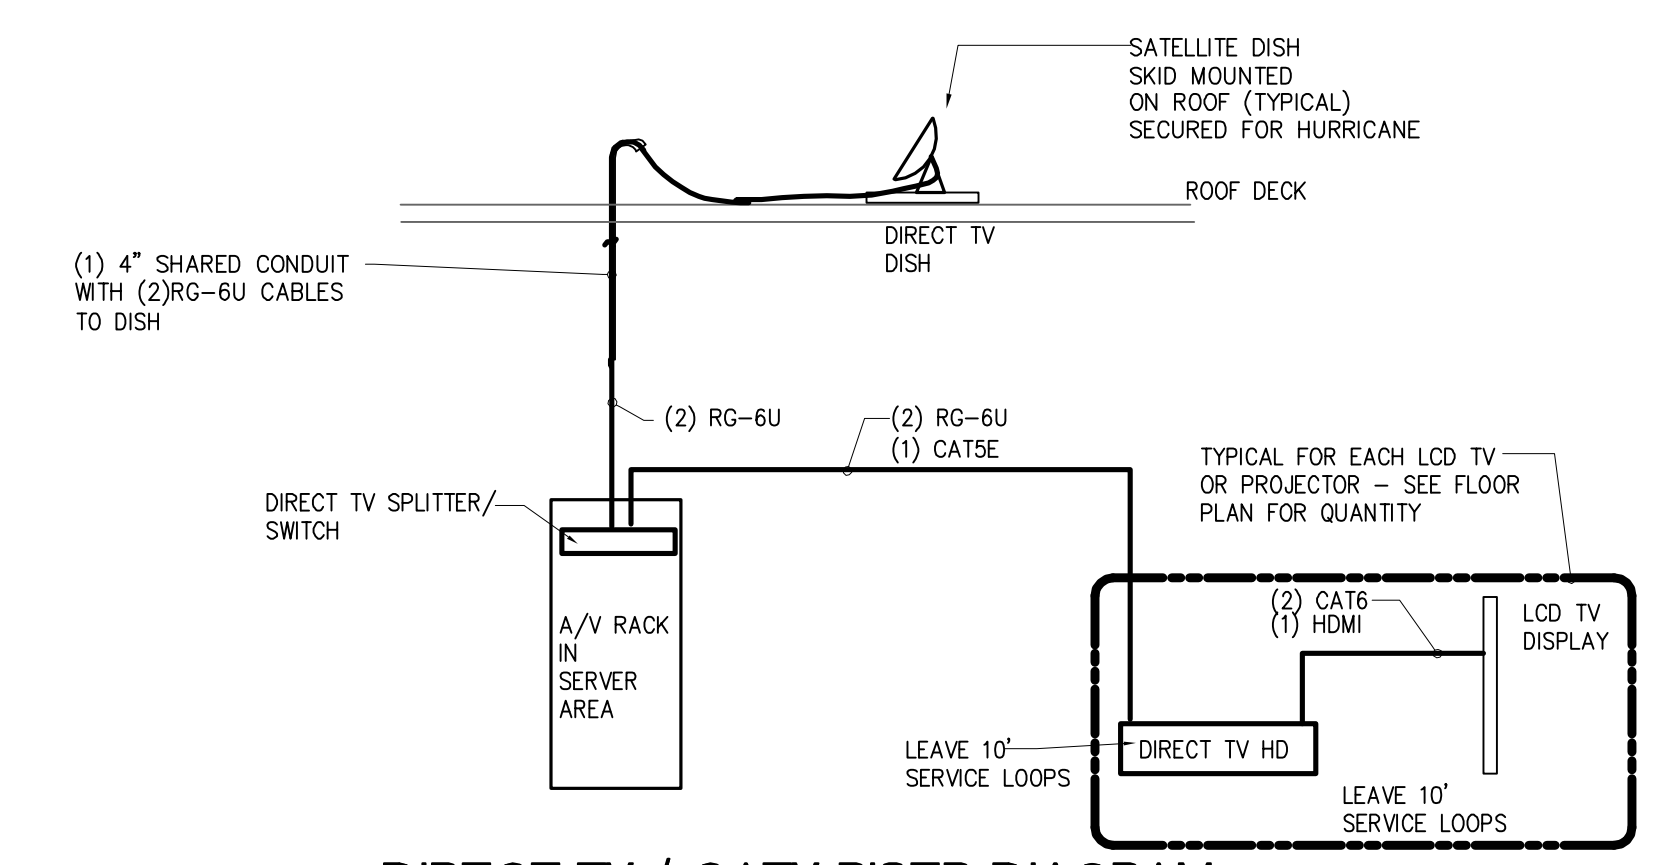

07 DIRECT TV / CATV RISER DIAGRAM
SCALE: NO SCALE

5G Studio Collaborative, LLC.
800 Jackson | Suite 600 | Dallas, TX 75202
260 Peachtree Street | Suite 500 | Atlanta, GA 30303

ARCHITECT
5G Studio Collaborative, LLC.
800 Jackson St, Suite 600
Dallas, TX 75202
Rick Walker - 214.670.0050

STRUCTURAL ENGINEER
L.A. Fuess Partners Engineers
3333 Lee Parkway, Suite 300
Dallas, TX 75219
Jeff Fray - 214.871.0110

MEP ENGINEER
EnviroDesign, Inc.
900 Ranch Rd 620 So., Suite C101-301
Austin, TX 78738
Sam Patton - 512.693.9015
Leas PE Firm Number 1-5847



DRAWINGS & SPECIFICATIONS ARE THE PROPERTY OF ENVIRODESIGN. COPIES OF THE DRAWINGS & SPECIFICATIONS RETAINED BY THE CLIENT MAY BE UTILIZED ONLY FOR HIS USE & FOR OCCUPANCY OF THE PROJECT FOR WHICH THEY WERE PREPARED, & NOT FOR THE CONSTRUCTION OF ANY OTHER PROJECT.

REV.	DATE	PERMIT ISSUE	ISSUE
5/12/17		PERMIT ISSUE	
5/24/17		ISSUE FOR BID	

CINERGY AMARILLO

SHEET DESCRIPTION
UPPER LEVEL FLOOR PLAN
LOW VOLTAGE

2016-151 PROJECT NUMBER
E8.2 SHEET NUMBER