


Plotted By: Dan Habetter 24 May, 2017 Drawing File: E:\Dropbox (EnviroDesign)\EnviroDesign Team Folder\Current\2017-055 Cinergy Amarillo\2017-055E91 NCM.dwg

ALL DRAWINGS AND WRITTEN MATERIAL APPEARING HEREIN CONSTITUTE ORIGINAL AND UNPUBLISHED WORK OF THE ENGINEER AND MAY NOT BE DUPLICATED, USED OR DISCLOSED WITHOUT WRITTEN CONSENT OF ENVIRODESIGN, INC. © 2017 ENVIRODESIGN, INC. ALL RIGHTS RESERVED.

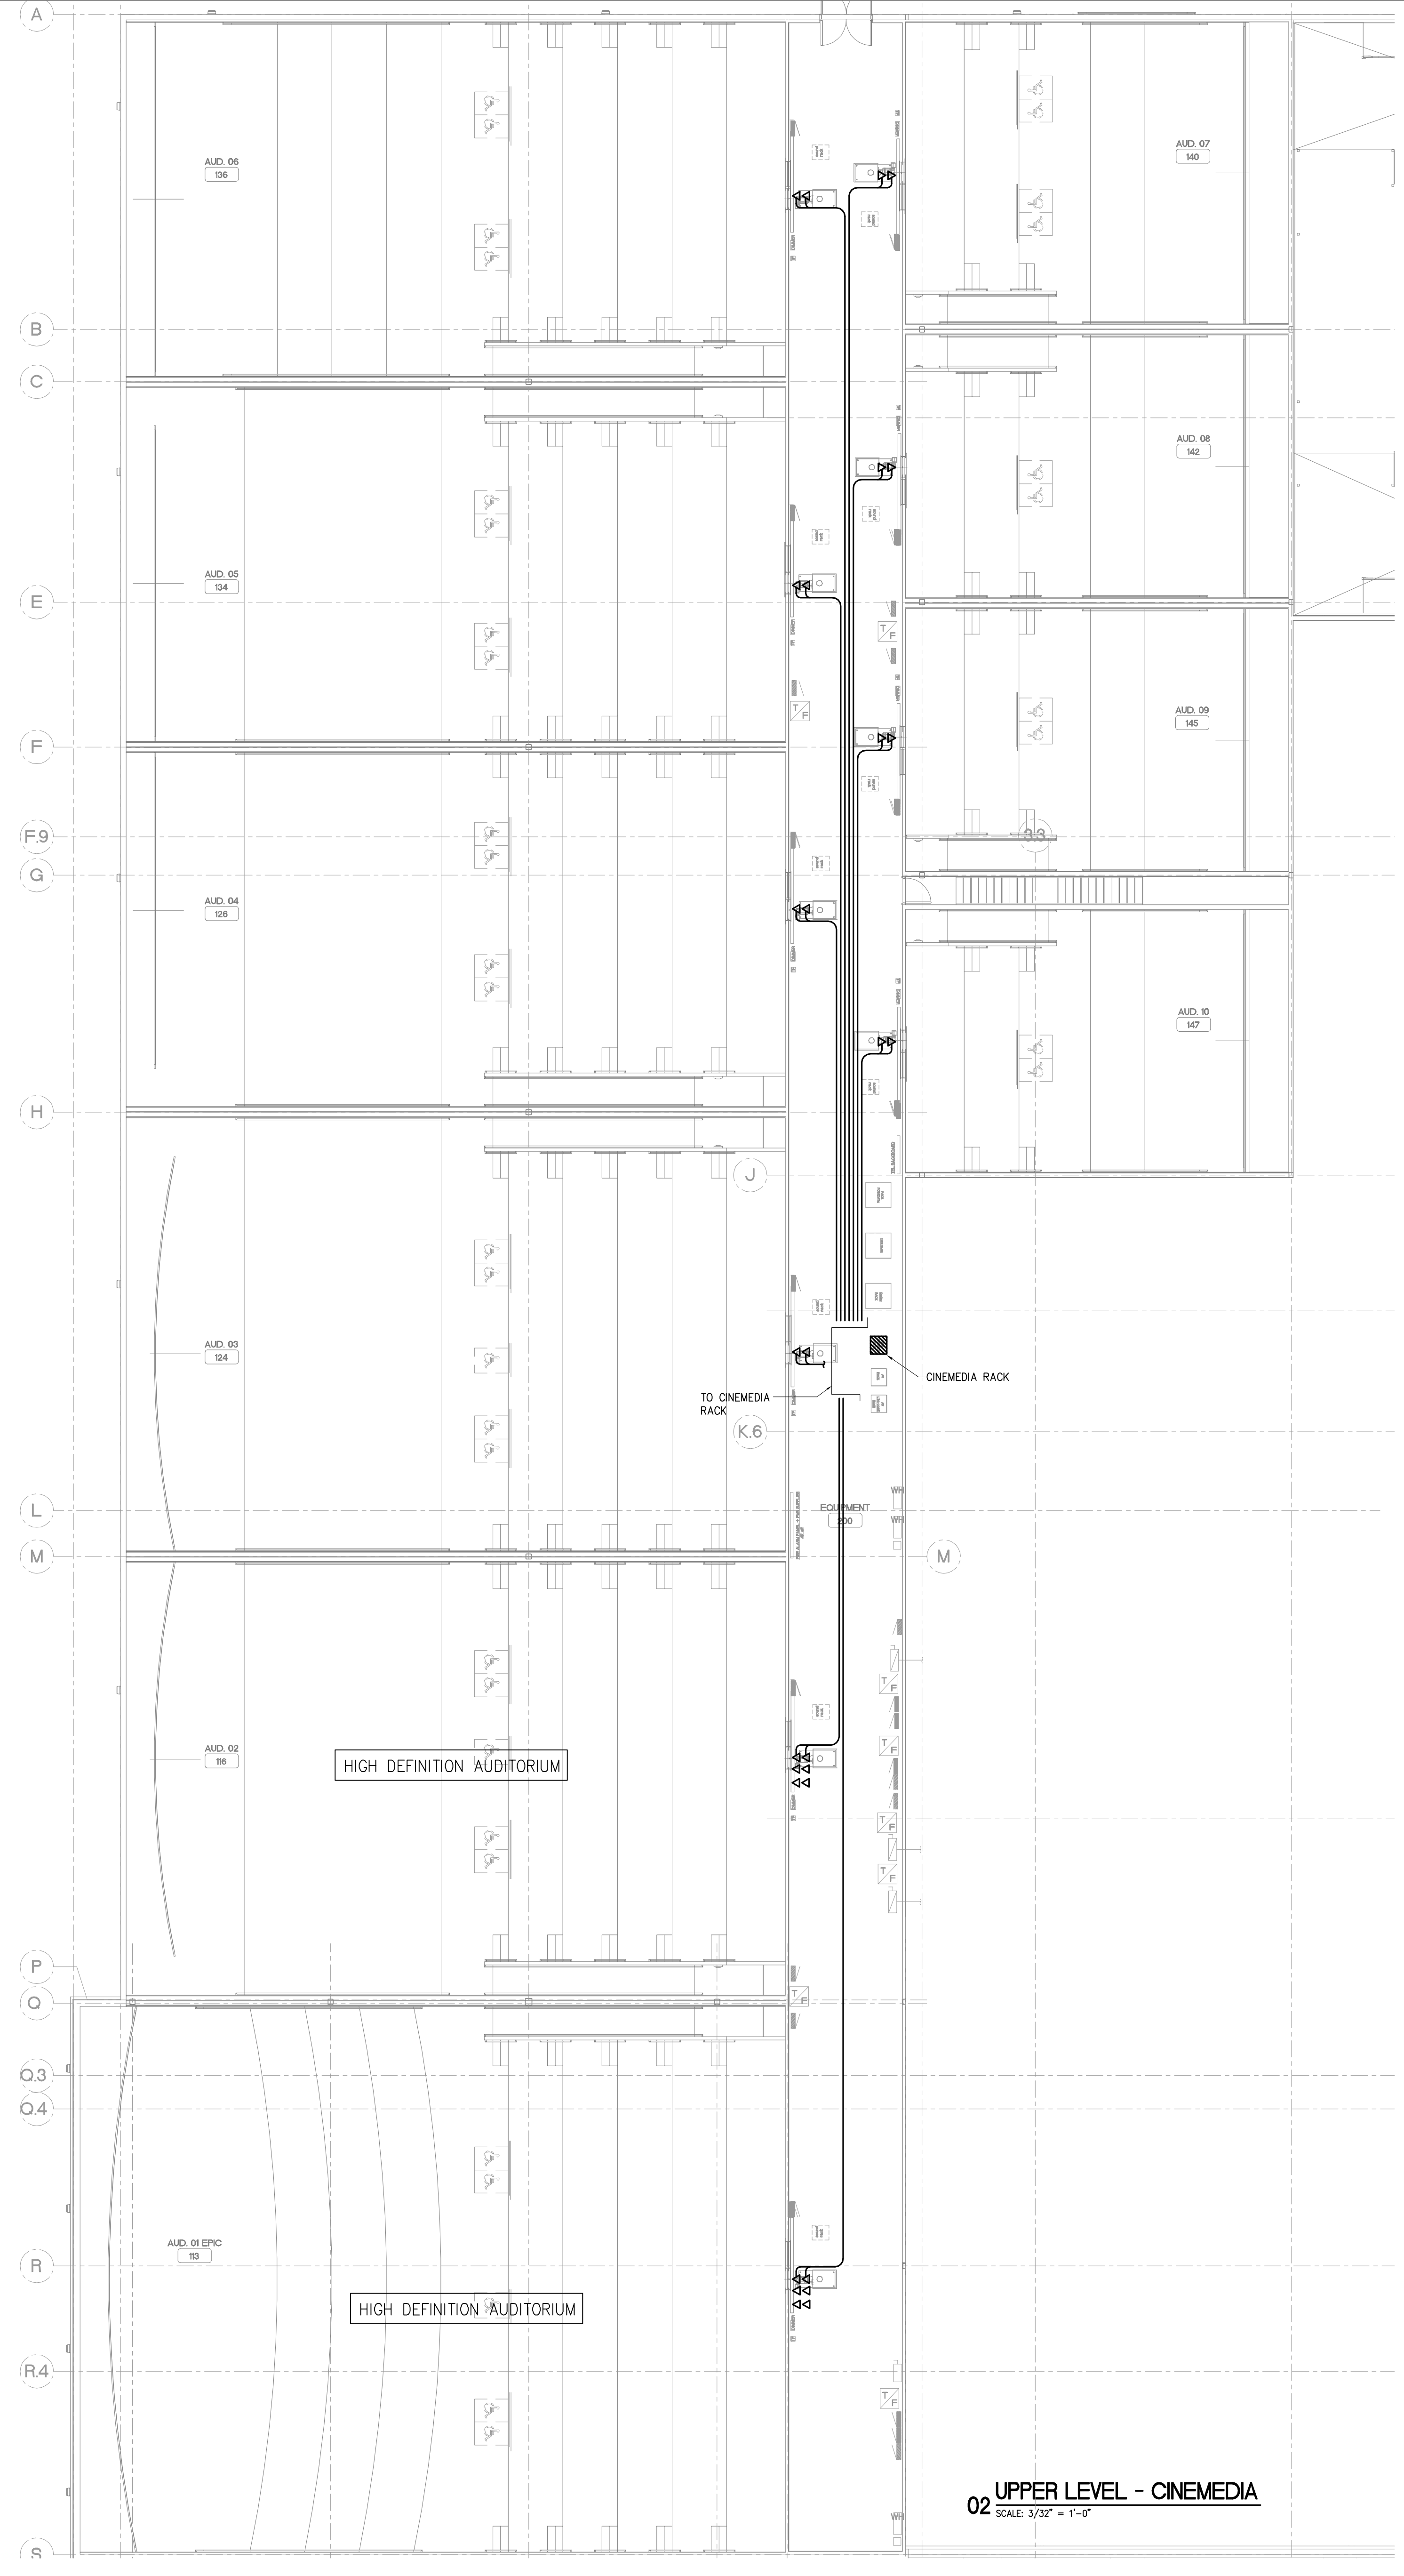


**02 UPPER LEVEL - CINEMEDIA**  
SCALE: 3/32" = 1'-0"

**CINEMEDIA INSTALLATION NOTES:**

- EQUIPMENT AND WIRING TO BE FURNISHED & INSTALLED AS INDICATED ON THE MATRIX OF RESPONSIBILITY AND AS NOTED BELOW.
- ENTIRE INSTALLATION SHALL MEET THE REQUIREMENTS OF ANSI CAT 5 INSTALLATION. ALL CABLE RUNS SHALL BE DIRECT AS POSSIBLE WITH NO SPLICES.
- CONTRACTORS SHALL PROVIDE ALL DATA OUTLETS, CONNECTORS, DEVICES, ETC.
- CONTRACTOR SHALL PUNCH DOWN AT PATCH PANEL & ALL CONNECTORS.
- CONTRACTOR SHALL LABEL EACH CABLE AND END TERMINATION.
- CONTRACTOR SHALL TEST, AND CERTIFY INSTALLATION, AND SUBMIT TEST REPORT UPON COMPLETION.
- THE CINEMEDIA DATA RACK WILL BE FURNISHED BY THE OWNER. THE CONTRACTOR WILL SET IN PLACE AND INSTALL POWER RECEPTACLES. THE CONTRACTOR WILL LEAVE 7" OF SLACK AT ALL LOW VOLTAGE CABLES FOR TERMINATIONS BY OTHERS.

**GENERAL NOTES**

- REFER TO ARCHITECTURAL PLANS FOR EXACT LOCATIONS AND DIMENSIONS OF EQUIPMENT.
- REFER TO OTHER ELECTRICAL SHEETS AND SPECIAL SYSTEMS SHEETS FOR ADDITIONAL SCHEDULES AND DETAILS.
- ALL JUNCTION BOXES SHALL BE SURFACE MOUNTED ON DEMISING WALLS BETWEEN AUDITORIUMS.
- COORDINATE THE LOCATION OF CINEMEDIA EQUIPMENT AND DEVICES WITH THE ELECTRICAL AND LOW VOLTAGE CONTRACTORS.
- REFER TO CINEMEDIA RISER DIAGRAM FOR ADDITIONAL INFORMATION.

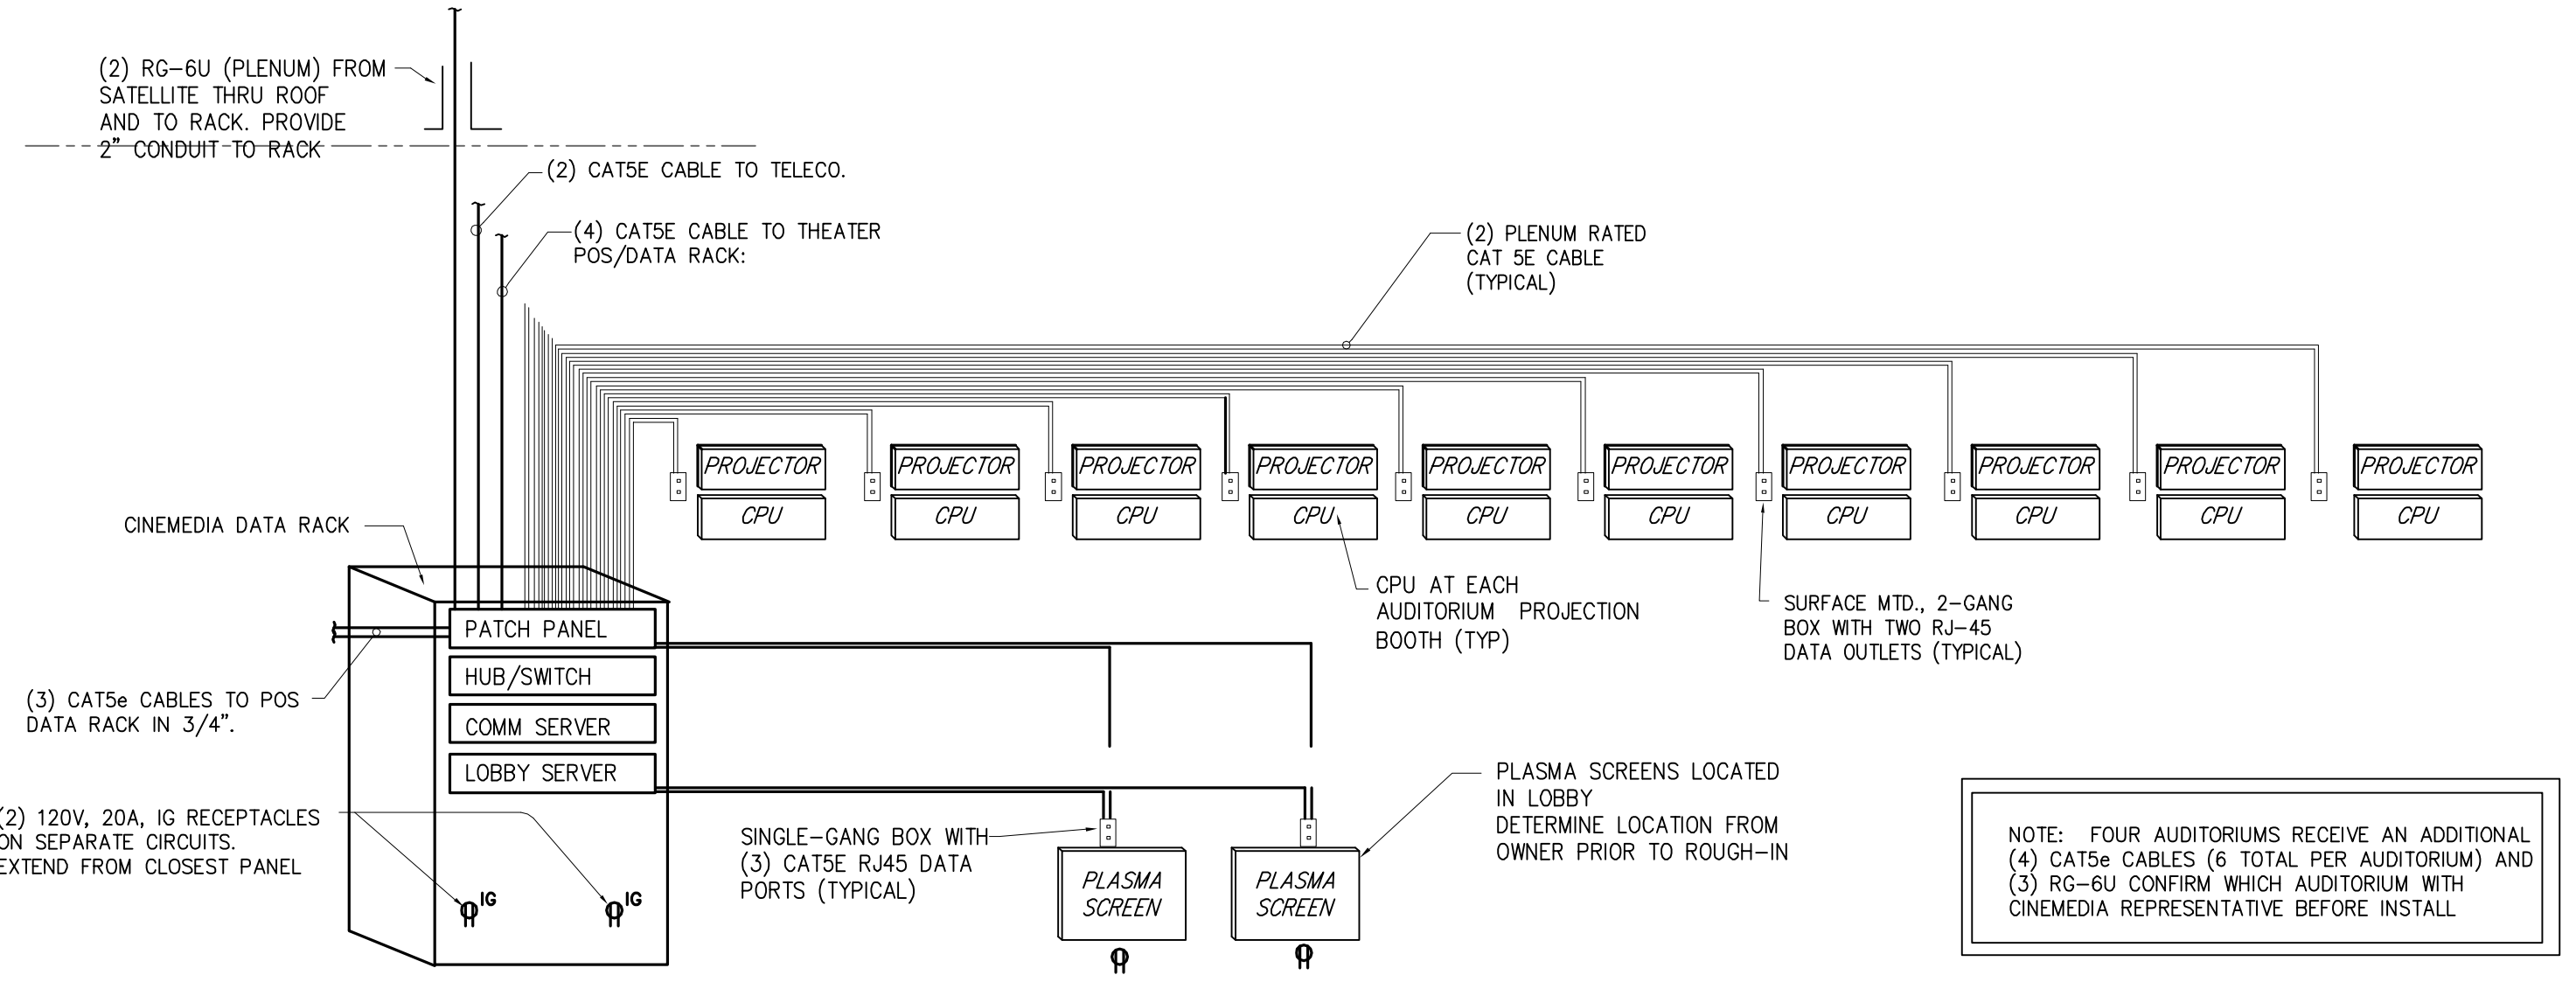

**21 CINEMEDIA CAT 5E RISER DIAGRAM**  
SCALE: NO SCALE



800 Jackson | Suite 600 | Dallas, TX 75202  
260 Peachtree Street | Suite 500 | Atlanta, GA 30303

**ARCHITECT**  
5G Studio Collaborative, LLC.  
800 Jackson St, Suite 600  
Dallas, TX 75202  
Rick Walker - 214.670.0050

**STRUCTURAL ENGINEER**  
L.A. Fuess Partners Engineers  
3333 Lee Parkway, Suite 300  
Dallas, TX 75219  
Jeff Tracy - 214.811.0110

**MEP ENGINEER**  
EnviroDesign, Inc.  
900 Ranch Rd 620 So., Suite C101-301  
Austin, TX 78738  
Sam Patton - 512.693.9015  
Texas PE Firm Number 1-3847



DRAWINGS & SPECIFICATIONS ARE THE PROPERTY OF ENVIRODESIGN. COPIES OF THE DRAWINGS & SPECIFICATIONS RETAINED BY THE CLIENT MAY BE UTILIZED ONLY FOR HIS USE & FOR OCCUPANCY OF THE PROJECT FOR WHICH THEY WERE PREPARED, & NOT FOR THE CONSTRUCTION OF ANY OTHER PROJECT.  
P E C

REV.	DATE	PERMIT ISSUE	ISSUE
5/12/17		PERMIT ISSUE	
5/24/17		ISSUE FOR BID	

**CINERGY AMARILLO**  
SHEET DESCRIPTION  
**UPPER LEVEL FLOOR PLAN**  
**CINEMEDIA**

2016-151 PROJECT NUMBER  
**E9.1** SHEET NUMBER