


**GENERAL NOTES:**

- SLOPE ALL LOW SLOPE FLAT ROOF SURFACES 1/4" PER FOOT MINIMUM TO DRAIN UNLESS OTHERWISE NOTED.
- PROVIDE CRICKETS WHERE SHOWN AND WORK ROOFING AROUND ROOF DRAWINS, ROOF VENTS AND CURBS AS REQUIRED TO MAINTAIN ROOFING SYSTEM WARRANTY.
- INSTALL CONTINUOUS SELF ADHERING HIGH TEMPERATURE UNDERLAYMENT AT ALL SLOPED STANDING SEAM METAL ROOF AREAS.
- ALL ROOFING WORK TO MEET OR EXCEED NRCA CURRENT STANDARDS.
- ALL DOWNSPOUTS ARE BOOTED TO STORM SEWER. REF. 238 / A-312 FOR BOOT DETAIL.
- INSTALL ROOF VENT SYSTEM FOR VENTING THE STANDING SEAM METAL ROOFS AT JUNCTION TO MECHANICAL WELLS. PROVIDE CONTINUOUS VENT WITH 10" X 6" OPENING CUT INTO SHEATHING BETWEEN EACH TRUSS AROUND THE PERIMETER OF THE MECHANICAL WELL. REFER TO 239 / A312 SIMILAR AT ALL LOCATIONS.

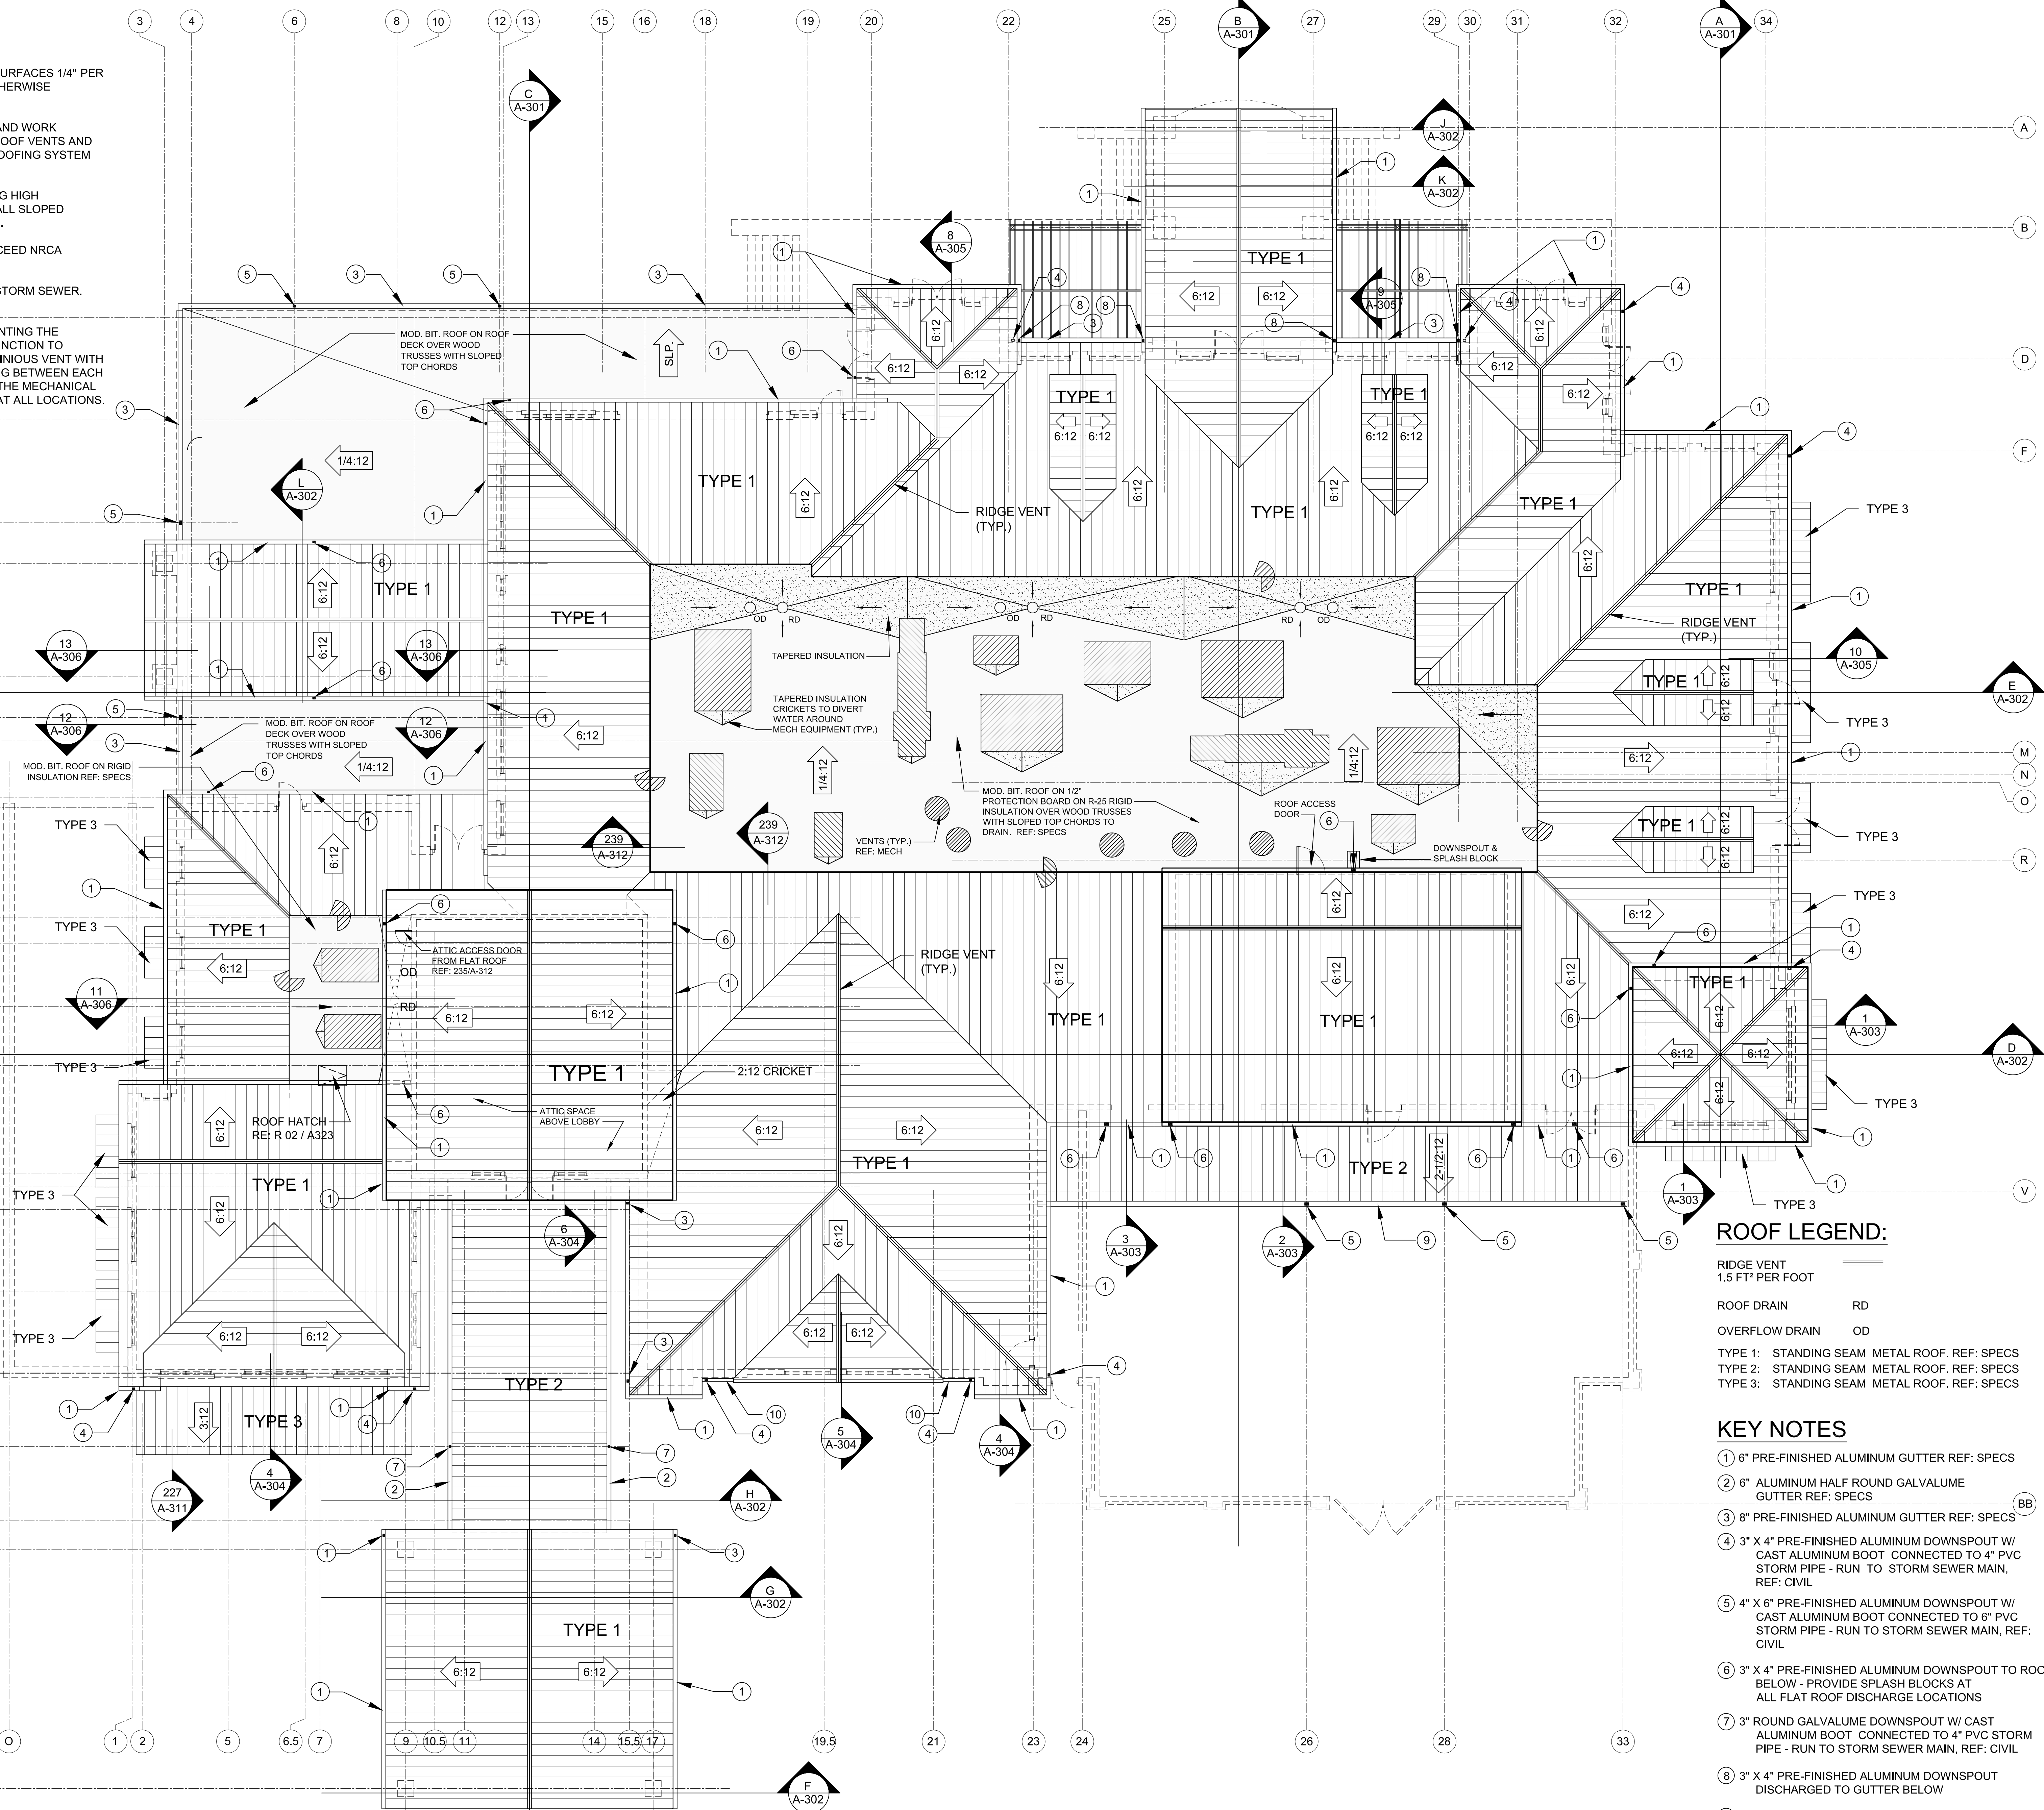

**ROOF LEGEND:**

- RIDGE VENT 1.5 FT<sup>2</sup> PER FOOT
- ROOF DRAIN RD
- OVERFLOW DRAIN OD
- TYPE 1: STANDING SEAM METAL ROOF. REF: SPECS
- TYPE 2: STANDING SEAM METAL ROOF. REF: SPECS
- TYPE 3: STANDING SEAM METAL ROOF. REF: SPECS

**KEY NOTES**

- 6" PRE-FINISHED ALUMINUM GUTTER REF: SPECS
- 6" ALUMINUM HALF ROUND GALVALUME GUTTER REF: SPECS
- 8" PRE-FINISHED ALUMINUM GUTTER REF: SPECS
- 3" X 4" PRE-FINISHED ALUMINUM DOWNSPOUT W/ CAST ALUMINUM BOOT CONNECTED TO 4" PVC STORM PIPE - RUN TO STORM SEWER MAIN, REF: CIVIL
- 4" X 6" PRE-FINISHED ALUMINUM DOWNSPOUT W/ CAST ALUMINUM BOOT CONNECTED TO 6" PVC STORM PIPE - RUN TO STORM SEWER MAIN, REF: CIVIL
- 3" X 4" PRE-FINISHED ALUMINUM DOWNSPOUT TO ROOF BELOW - PROVIDE SPLASH BLOCKS AT ALL FLAT ROOF DISCHARGE LOCATIONS
- 3" ROUND GALVALUME DOWNSPOUT W/ CAST ALUMINUM BOOT CONNECTED TO 4" PVC STORM PIPE - RUN TO STORM SEWER MAIN, REF: CIVIL
- 3" X 4" PRE-FINISHED ALUMINUM DOWNSPOUT DISCHARGED TO GUTTER BELOW
- 8" PRE-FINISHED ALUMINUM GUTTER
- 4" PRE-FINISHED ALUMINUM GUTTER

**1 ROOF PLAN**  
SCALE: 1/8" = 1'-0"

**REES**  
1025 N. Stemmons Freeway, Suite 737  
Dallas, Texas 75207  
214.522.7337 main

ARCHITECTURE PLANNING INTERIORS

**Civil Engineer**  
SCHRICKEL, ROLLINS AND ASSOCIATES, INC.  
1161 CORPORATE DRIVE WEST  
SUITE 200  
ARLINGTON, TEXAS 76006  
P: 817.649.3216

**Mechanical, Electrical, Plumbing Engineer**  
MEP SYSTEMS  
918 DRAGON STREET  
DALLAS, TEXAS 75247  
P: 214.915.0929

**Structural Engineer**  
RONALD A. ROBERTS ASSOCIATES, INC.  
2948 N. STEMMONS FREEWAY  
DALLAS, TEXAS 75247  
P: 214.637.5299

**Kitchen Consultant**  
PROFITABLE FOOD FACILITIES  
14026 Donart Drive  
POWAY, CALIFORNIA 92064  
P: 656.748.7333

**A/V Consultant**  
ACHEIVE AV, INC.  
730 Ward Dr.  
CEDAR HILL, TEXAS 75104  
P: 214.884.5951

**ARLINGTON**  
THE AMERICAN BEAR CITY

**CHESTER W. DITTO GOLF COURSE CLUBHOUSE**  
CITY OF ARLINGTON  
801 BROWN BLVD - ARLINGTON, TX 76011

|             |                   |
|-------------|-------------------|
| No.         | Date              |
| Revisions   |                   |
| Project No. | 21538.00          |
| Drawn       | KLH, DWM, KL, KJM |
| Checked     | MDS               |
| Approved    |                   |
| Key:        | Engineer          |

PLAN NORTH NORTH

**CONSTRUCTION DOCUMENTS**

Title: **ROOF PLAN**

Drawing No. **A-121**

Issue Date: **OCTOBER 25, 2017**

© COPYRIGHT REES ASSOCIATES, INC. 2017